


SYMBOL	DESCRIPTION
	DUPLEX OUTLET (GROUNDING TYPE)
	WEATHER PROOF DUPLEX OUTLET (GFI)
	WALL SWITCH CONTROLLED DUPLEX OUTLET
	SWITCHED OUTLET
	ABOVE COUNTER LOCATION
	FLUSH FLOOR WALL SWITCH CONTROLLED DUPLEX OUTLET OWNER VERIFY LOCATION
	220 VOLT OUTLET OR CONNECTION
	TELEVISION ANTENNA/CABLE OUTLET
	TELEPHONE OUTLET LOCATION
	DOOR CHIME LOCATION
	120 VOLT JUNCTION BOX
	SINGLE POLE WALL SWITCH
	SINGLE POLE WALL SWITCH WITH DIMMER
	3-WAY WALL SWITCH
	3-WAY WALL SWITCH WITH DIMMER
	CEILING MOUNTED & SUSPENDED LIGHT FIXTURE
	WALL BRACKET MOUNTED LIGHT FIXTURE
	SUSPENDED CEILING MOUNTED LIGHT FIXTURE (PENDANT)
	RECESSED DIRECTIONAL CEILING LIGHT FIXTURE
	RECESSED CEILING LIGHT FIXTURE
	RECESSED LIGHT FOR WET AREA
	RECESSED WALL WASHER
	RECESSED PIN LIGHT
	ONE TUBE UNDER COUNTER FLUORESCENT LIGHT
	EXTERIOR CAST ALUMINUM FLOOD LIGHTS
	CEILING MOUNTED FAN - PADDLE
	CEILING MOUNTED FAN - EXHAUST
	CEILING MOUNTED FAN AND HEATER
	CEILING MOUNTED FAN LIGHT AND HEATER
	PORCELAIN LAMPHOLDER
	DOOR BELL BUTTON
	SMOKE DETECTOR
	THERMOSTAT
	AUTOMATIC GARAGE DOOR OPENER OUTLET

© COPYRIGHT 2005 GARRELL ASSOCIATES INC.
* WARNING FEDERAL COPYRIGHT LAWS RESTRICTS
THE REMOVAL OF THIS NOTE.

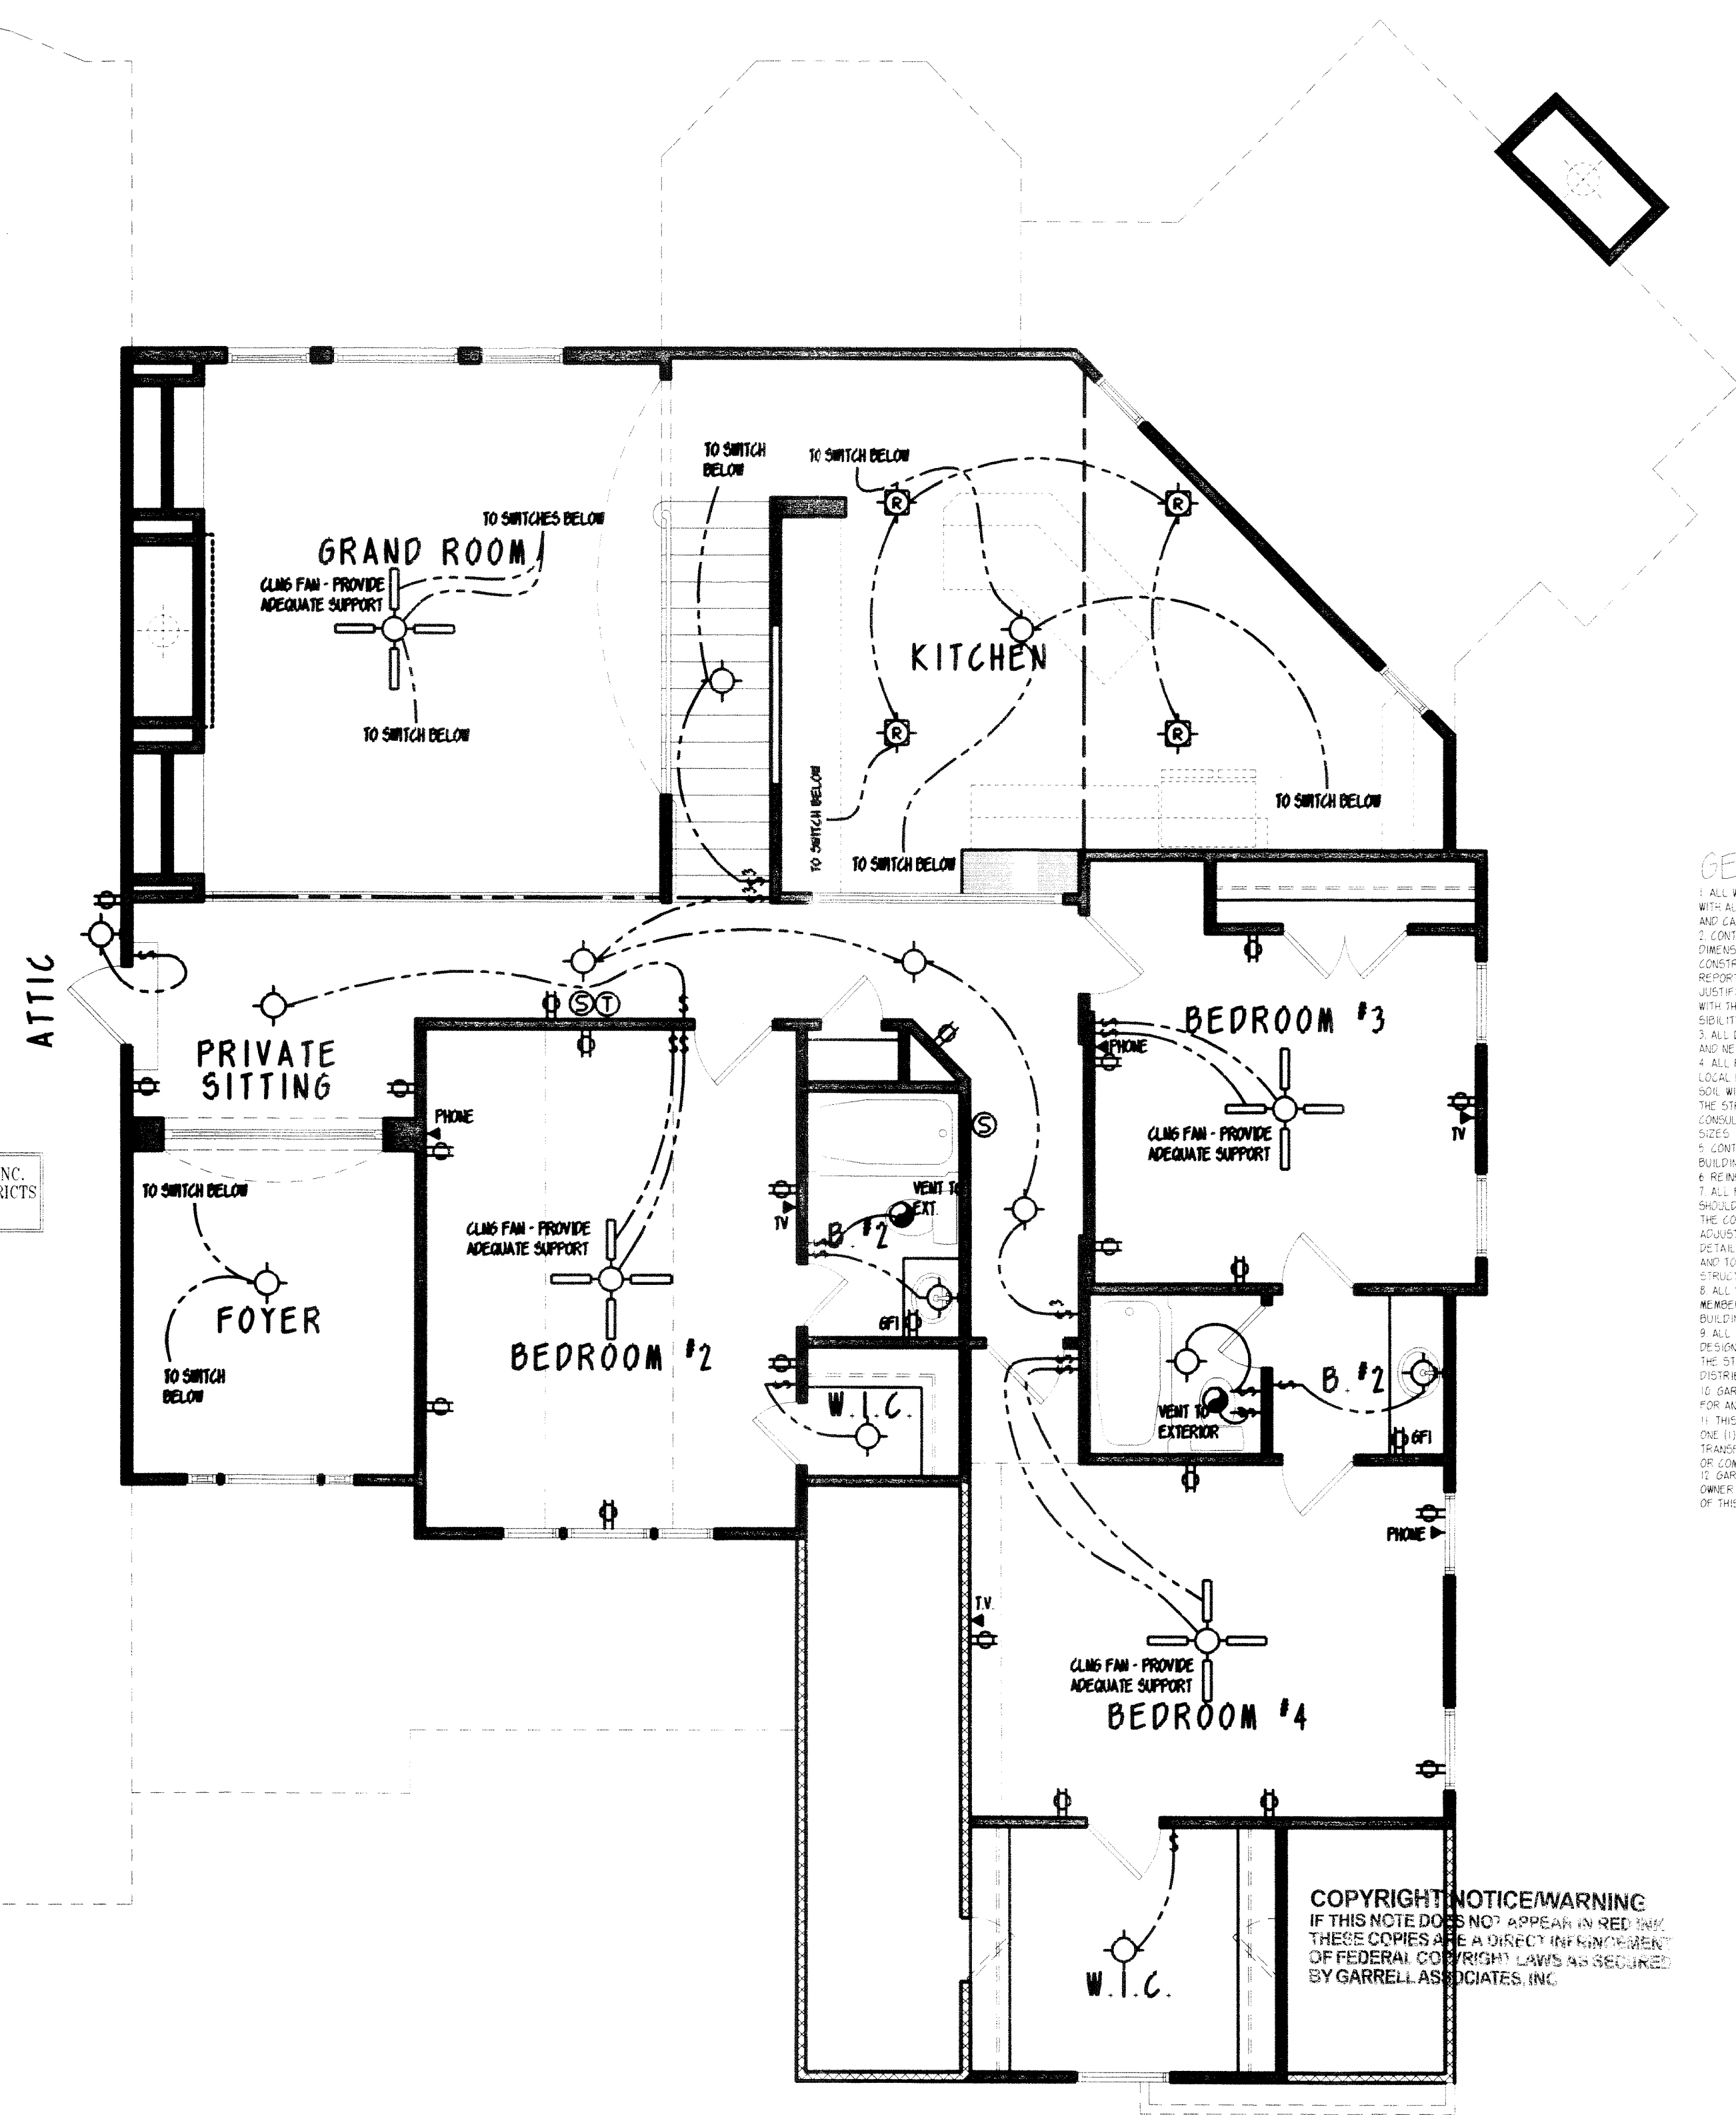

GENERAL NOTES

1. ALL WORK SHALL BE PERFORMED IN ACCORDANCE WITH ALL NATIONAL AND LOCAL CODES, REGULATIONS, AND EASY-TO-DO INTERNATIONAL BUILDING CODE.
2. CONTRACTOR SHALL VERIFY ALL CONDITIONS AND DIMENSIONS AT THE SITE BEFORE BEGINNING CONSTRUCTION. ANY DISCREPANCIES SHALL BE REPORTED TO GARRELL ASSOCIATES, INC. FOR JUSTIFICATION OF CORRECTION BEFORE PROCEEDING WITH THE WORK. CONTRACTOR SHALL ASSUME RESPONSIBILITY FOR ERRORS THAT ARE NOT REPORTED.
3. ALL DIMENSIONS SHALL BE READ OR CALCULATED AND NEVER GUESSED.
4. ALL PORTIONS OF FOOTINGS ARE TO BE BELOW LOCAL FLOOR LINES AND MUST REST ON UNDISTURBED SOIL WITH ADEQUATE BEARING CAPACITY TO SUPPORT THE STRUCTURE. A LOCAL ENGINEER MUST BE CONSULTED FOR PROPER FOOTING AND REINFORCEMENT SIZES.
5. CONTRACTOR TO ENSURE COMPATIBILITY OF THE BUILDING WITH ALL SITE REQUIREMENTS.
6. REINFORCE FOUNDATION WALLS PER LOCAL CODES.
7. ALL FOUNDATION AND STRUCTURAL MEMBERS SHOULD BE VERIFIED AND STAMPED BY AN ENGINEER. THE CONTRACTOR IS RESPONSIBLE FOR THE ADJUSTMENT AND VERIFICATION OF ALL STRUCTURAL DETAILS AND CONDITIONS TO MEET ALL LOCAL CODES AND TO INSURE A WELL CONSTRUCTED AND SAFE STRUCTURE.
8. ALL WOOD, CONCRETE AND STEEL STRUCTURAL MEMBERS ARE TO MEET NATIONAL, STATE AND LOCAL BUILDING CODES.
9. ALL COLUMNS OR SOLID FRAMING SHALL BE DESIGNED TO CARRY AND TERMINATE LOADS THROUGH THE STRUCTURE TO FOUNDATION ELEMENTS THAT DISTRIBUTE THE LOADS TO FULL CAPACITY SOILS.
10. GARRELL ASSOCIATES ASSUMES NO LIABILITY FOR ANY HOME CONSTRUCTION FROM THIS PLAN.
11. THIS DESIGN LICENSE IS RELEASED FOR THE US BUILT STRUCTURE ONLY AND IS NOT TRANSFERABLE TO ANY OTHER INDIVIDUAL OR COMPANY.
12. GARRELL ASSOCIATES, INC. IS THE SOLE OWNER OF THIS OR ANY DERIVATIVE MODIFICATION OF THIS COPYRIGHT PROTECTED PLAN.

COPYRIGHT NOTICE/WARNING
IF THIS NOTE DOES NOT APPEAR IN RED INK,
THIS COPIES ARE A DIRECT VIOLATION OF
FEDERAL COPYRIGHT LAWS AS REQUIRED
BY GARRELL ASSOCIATES, INC.

SECOND FLOOR ELECTRICAL PLAN

SCALE: 1/4" = 1'-0"

NOTES: THE DESIGN DEPICTED IN THESE DRAWINGS ARE PROTECTED UNDER FEDERAL COPYRIGHT LAWS AND ARE NOT RELEASED TO THIRD PARTIES FOR REPRODUCTION OR MODIFICATION. THESE DRAWINGS AND ITS REPRODUCTIONS ARE THE PROPERTY OF GARRELL ASSOCIATES, INC. AND MAY NOT BE REPRODUCED OR TRANSMITTED IN ANY FORM OR BY ANY MEANS, ELECTRONIC OR MECHANICAL, INCLUDING PHOTOCOPYING, RECORDING, OR BY ANY INFORMATION STORAGE AND RETRIEVAL SYSTEM, WITHOUT THE WRITTEN PERMISSION OF GARRELL ASSOCIATES, INC.

PLAN BOOK

GARRELL ASSOCIATES INC.

7200 PEACHTREE IND., BLDG.
SUITE 100, ATLANTA, GA 30324
PHONE: (770) 614-3239
WWW.GARRELLASSOCIATES.COM

TRE'S MAISON

SECOND FLOOR ELECTRICAL PLAN

2-23-01

REV. NO. REV. DATE

1 4-7-05 TC

THIS COPYRIGHTED DESIGN IS THE SOLE
PROPERTY OF GARRELL ASSOCIATES, INC.
AND MAY NOT BE USED OR REPRODUCED
WITHOUT THE EXPRESSED WRITTEN
CONSENT OF GARRELL ASSOCIATES, INC.


CAUTION: ONLY A QUALIFIED DESIGNER,
ARCHITECT, CONTRACTOR, OR STRUCTURAL
ENGINEER SHOULD ATTEMPT TO MODIFY
THIS PLAN.

01049

DRAWN SHEET NO

VD

W2

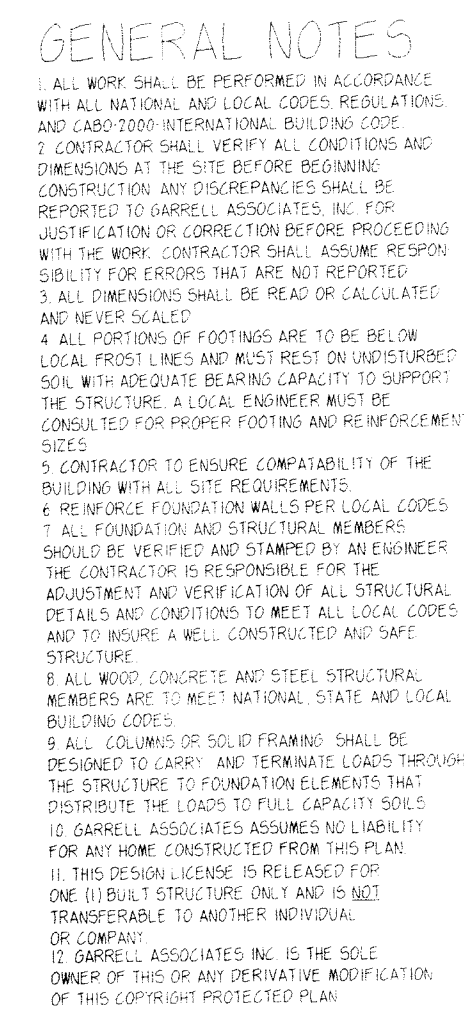

COPYRIGHT NOTICE/WARNING
IF THIS NOTE DOES NOT APPEAR IN RED INK
THESE COPIES ARE A DIRECT INFRINGEMENT
OF FEDERAL COPYRIGHT LAWS AS SECURED
BY GARRELL ASSOCIATES, INC.

PLAN BOOK



790 PEACHTREE IND. BLVD.
SUITE 200, SUWANEE, GA 30024
PHONE (770) 614-3239
WWW.GARRELLASSOCIATES.COM

TRE'S MAISON

REAR ELEVATION

2-23-01


[illegible]

THIS COPYRIGHTED DESIGN IS THE SOLE
PROPERTY OF GARRELL ASSOCIATES, INC.
AND MAY NOT BE USED OR REPRODUCED
WITHOUT THE EXPRESSED WRITTEN
CONSENT OF GARRELL ASSOCIATES, INC.

CAUTION: ONLY A QUALIFIED DESIGNER,
ARCHITECT, CONTRACTOR, OR STRUCTURAL
ENGINEER SHOULD ATTEMPT TO MODIFY
THIS PLAN.

01049

DRAWN	SHEET NO
VD	RE

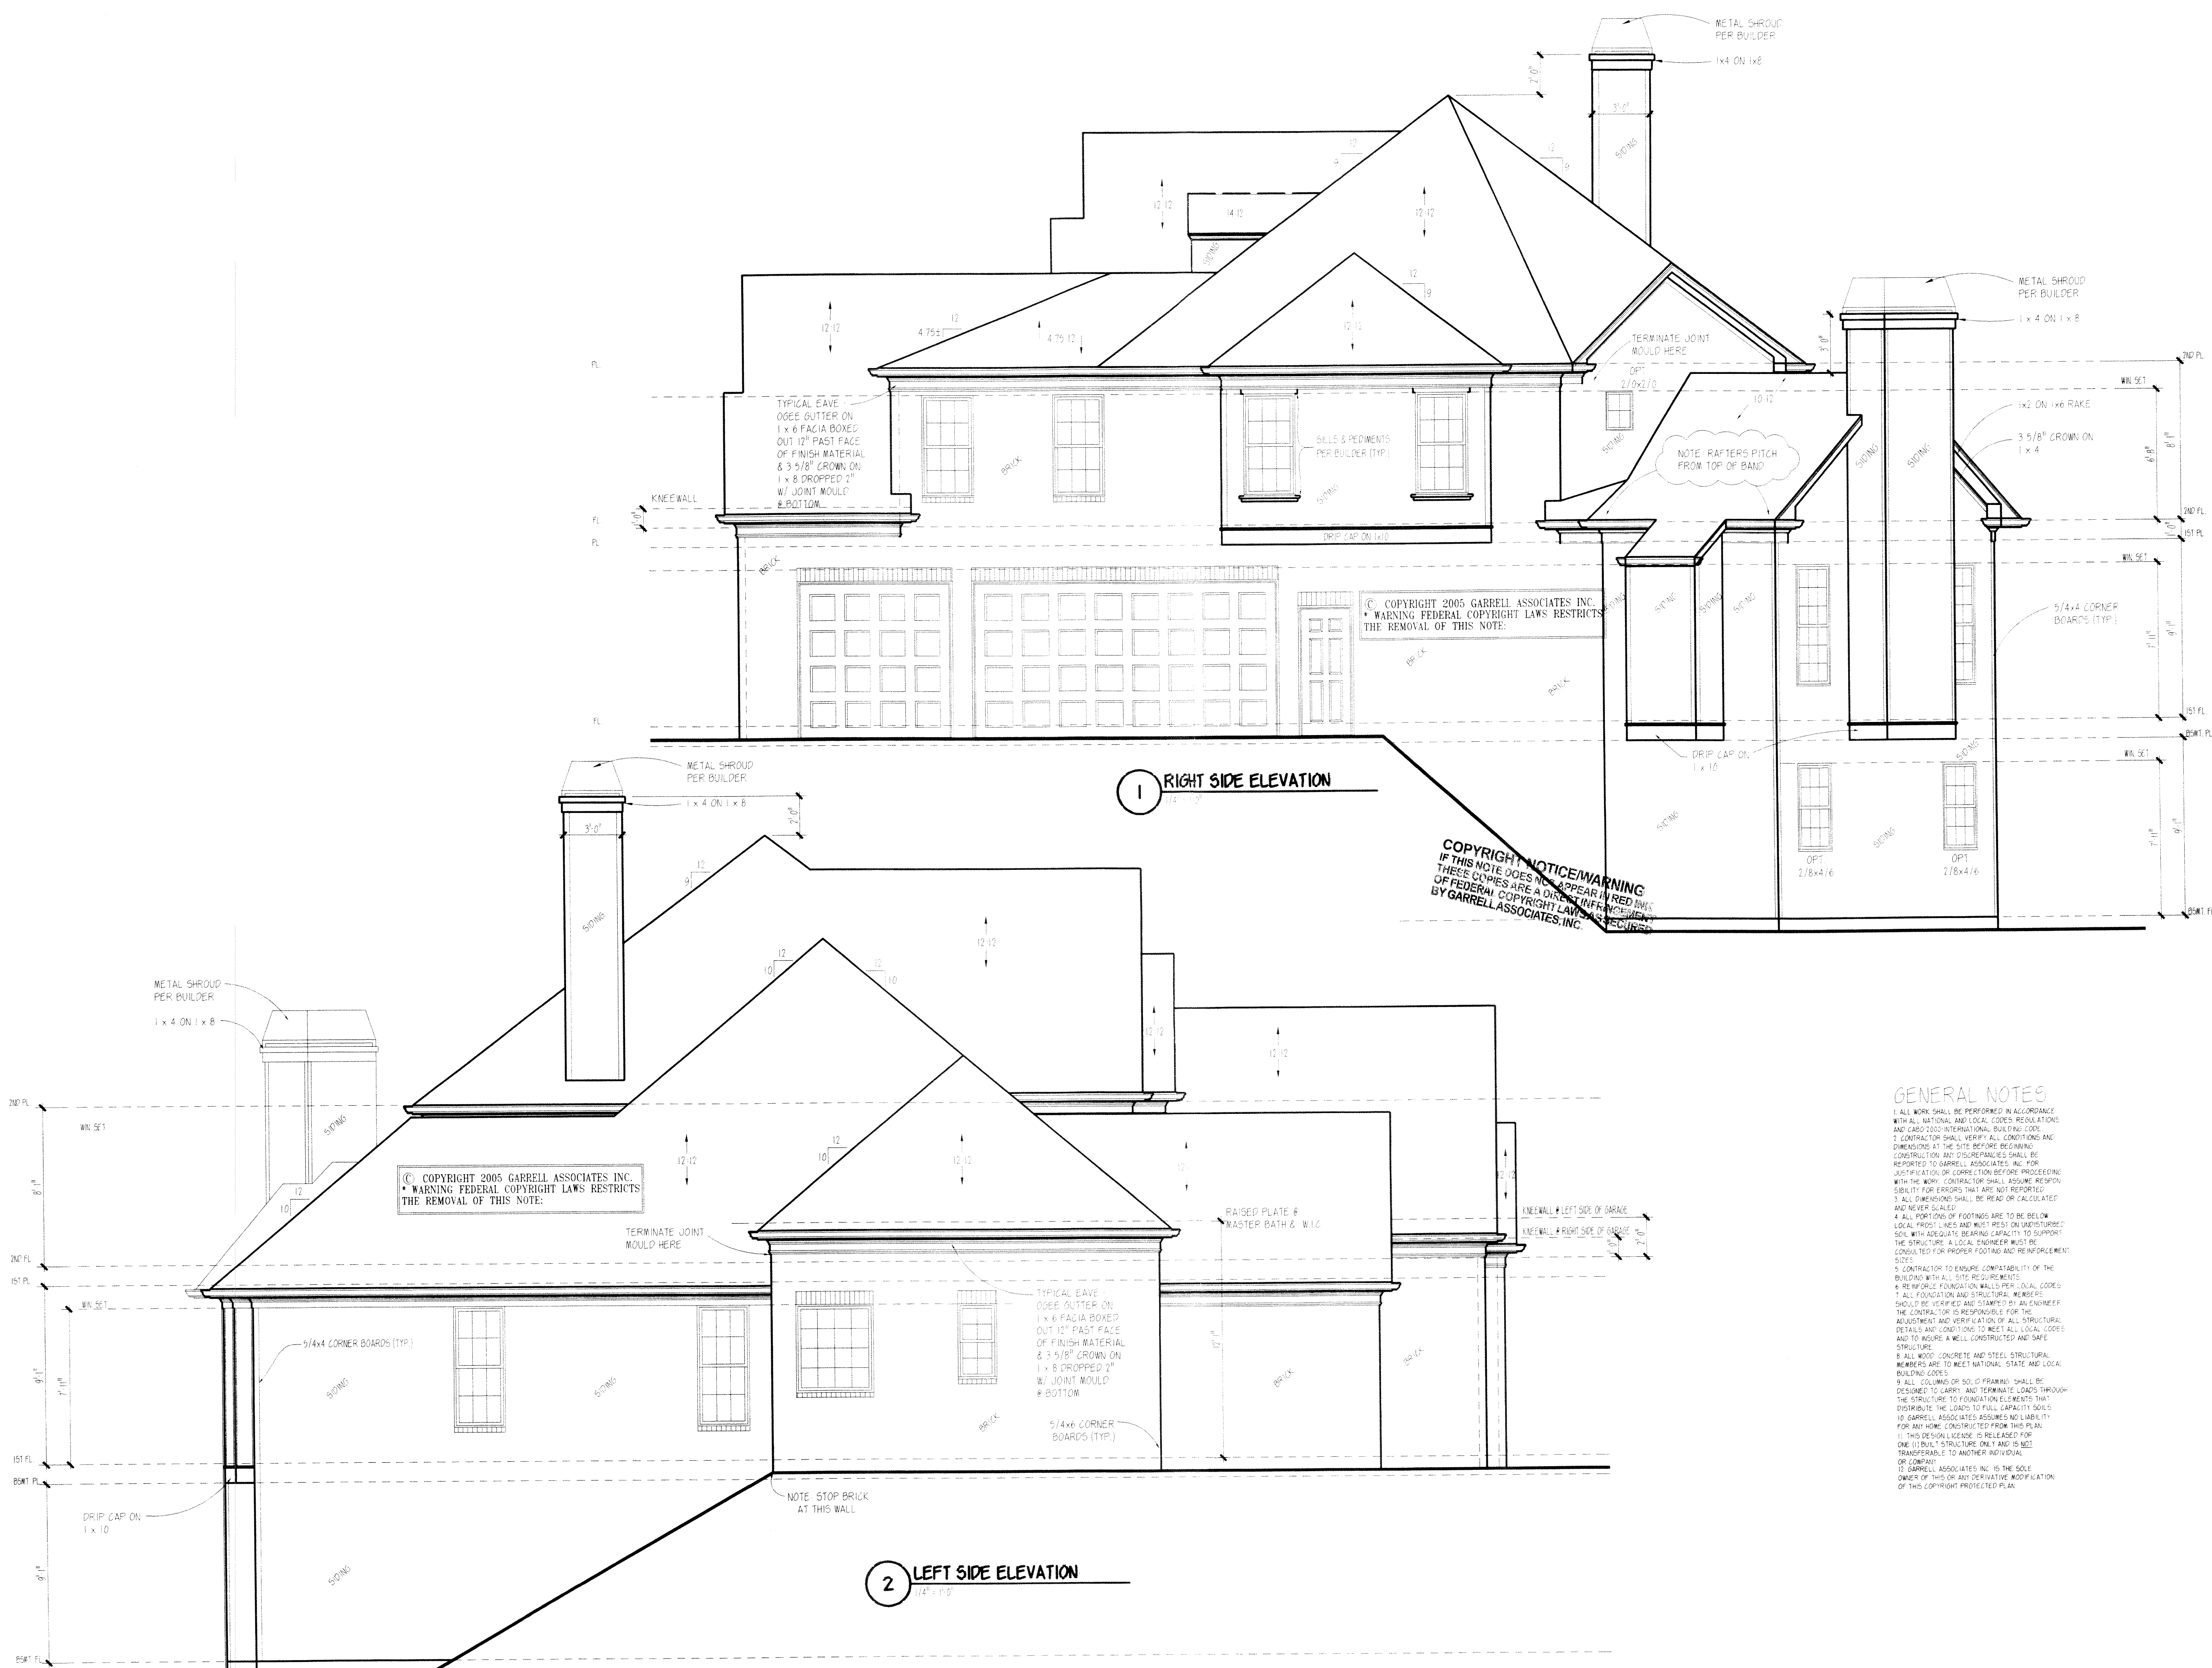

NOTES: THE DESIGN DETAIL IN THESE DRAWINGS ARE NOT RELEASED TO THIRD PARTIES FOR REPRODUCTION OR ANY DERIVATIVE WORKS OF REPRODUCTION. THESE DRAWINGS ARE THE PROPERTY OF GARRELL ASSOCIATES, INC. AND ARE NOT TO BE REPRODUCED OR TRANSMITTED IN ANY FORM OR BY ANY MEANS, ELECTRONIC OR MECHANICAL, INCLUDING PHOTOCOPYING, RECORDING, OR BY ANY INFORMATION STORAGE AND RETRIEVAL SYSTEM. WITHOUT THE WRITTEN PERMISSION OF GARRELL ASSOCIATES, INC.

- GENERAL NOTES**
1. ALL WORK SHALL BE PERFORMED IN ACCORDANCE WITH ALL NATIONAL AND LOCAL CODES, REGULATIONS AND CADD 2000 INTERNATIONAL BUILDING CODES.
 2. CONTRACTOR SHALL VERIFY ALL CONDITIONS AND DIMENSIONS AT THE SITE BEFORE BEGINNING CONSTRUCTION AND DISCREPANCIES SHALL BE REPORTED TO GARRELL ASSOCIATES, INC. FOR JUSTIFICATION OR CORRECTION BEFORE PROCEEDING WITH THE WORK. CONTRACTOR SHALL ASSUME RESPONSIBILITY FOR ERRORS THAT ARE NOT REPORTED.
 3. ALL DIMENSIONS SHALL BE READ OR CALCULATED AND NEVER SCALED.
 4. ALL PORTIONS OF FOOTINGS ARE TO BE BELOW LOCAL FROST LINES AND MUST REST ON UNDISTURBED SOIL WITH ADEQUATE BEARING CAPACITY TO SUPPORT THE STRUCTURE. A LOCAL ENGINEER MUST BE CONSULTED FOR PROPER FOOTING AND REINFORCEMENT SIZES.
 5. CONTRACTOR TO ENSURE COMPATIBILITY OF THE BUILDING WITH ALL SITE REQUIREMENTS.
 6. REINFORCE FOUNDATION WALLS PER LOCAL CODES.
 7. ALL FOUNDATION AND STRUCTURAL MEMBERS SHOULD BE VERIFIED AND STAMPED BY AN ENGINEER. THE CONTRACTOR IS RESPONSIBLE FOR THE ADJUSTMENT AND VERIFICATION OF ALL STRUCTURAL DETAILS AND CONDITIONS TO MEET ALL LOCAL CODES AND TO INSURE A WELL CONSTRUCTED AND SAFE STRUCTURE.
 8. ALL WOOD, CONCRETE AND STEEL STRUCTURAL MEMBERS ARE TO MEET NATIONAL, STATE AND LOCAL BUILDING CODES.
 9. ALL COLUMNS OR SOLID FRAMING SHALL BE DESIGNED TO CARRY AND TERMINATE LOADS THROUGH THE STRUCTURE TO FOUNDATION ELEMENTS THAT DISTRIBUTE THE LOADS TO FULL CAPACITY SOILS.
 10. GARRELL ASSOCIATES ASSUMES NO LIABILITY FOR ANY HOME CONSTRUCTED FROM THIS PLAN.
 11. THIS DESIGN/CONTRACT IS RELEASED FOR ONE (1) BUILDING STRUCTURE ONLY AND IS NOT TRANSFERABLE TO ANOTHER INDIVIDUAL, OR COMPANY.
 12. GARRELL ASSOCIATES, INC. IS THE SOLE OWNER OF THIS OR ANY DERIVATIVE MODIFICATION OF THIS COPYRIGHT PROTECTED PLAN.

PLAN BOOK

GARRELL
ASSOCIATES, INC.
790 PEACHTREE IND. BLVD.
SUITE 200, SUWANEE, GA 30024
(770) 477-1111
WWW.GARRELLASSOCIATES.COM

TRE'S MAISON

SIDE ELEVATIONS

2-23-01


REV. NO.	REV. DATE
1	4-7-05 TC

THIS COPYRIGHTED DESIGN IS THE SOLE PROPERTY OF GARRELL ASSOCIATES, INC. AND MAY NOT BE USED OR REPRODUCED WITHOUT THE EXPRESSED WRITTEN CONSENT OF GARRELL ASSOCIATES, INC.

CAUTION: ONLY A QUALIFIED DESIGNER, ARCHITECT, CONTRACTOR OR STRUCTURAL ENGINEER SHOULD ATTEMPT TO MODIFY THIS PLAN.

01049

DRAWN	SHEET NO
VD	SE

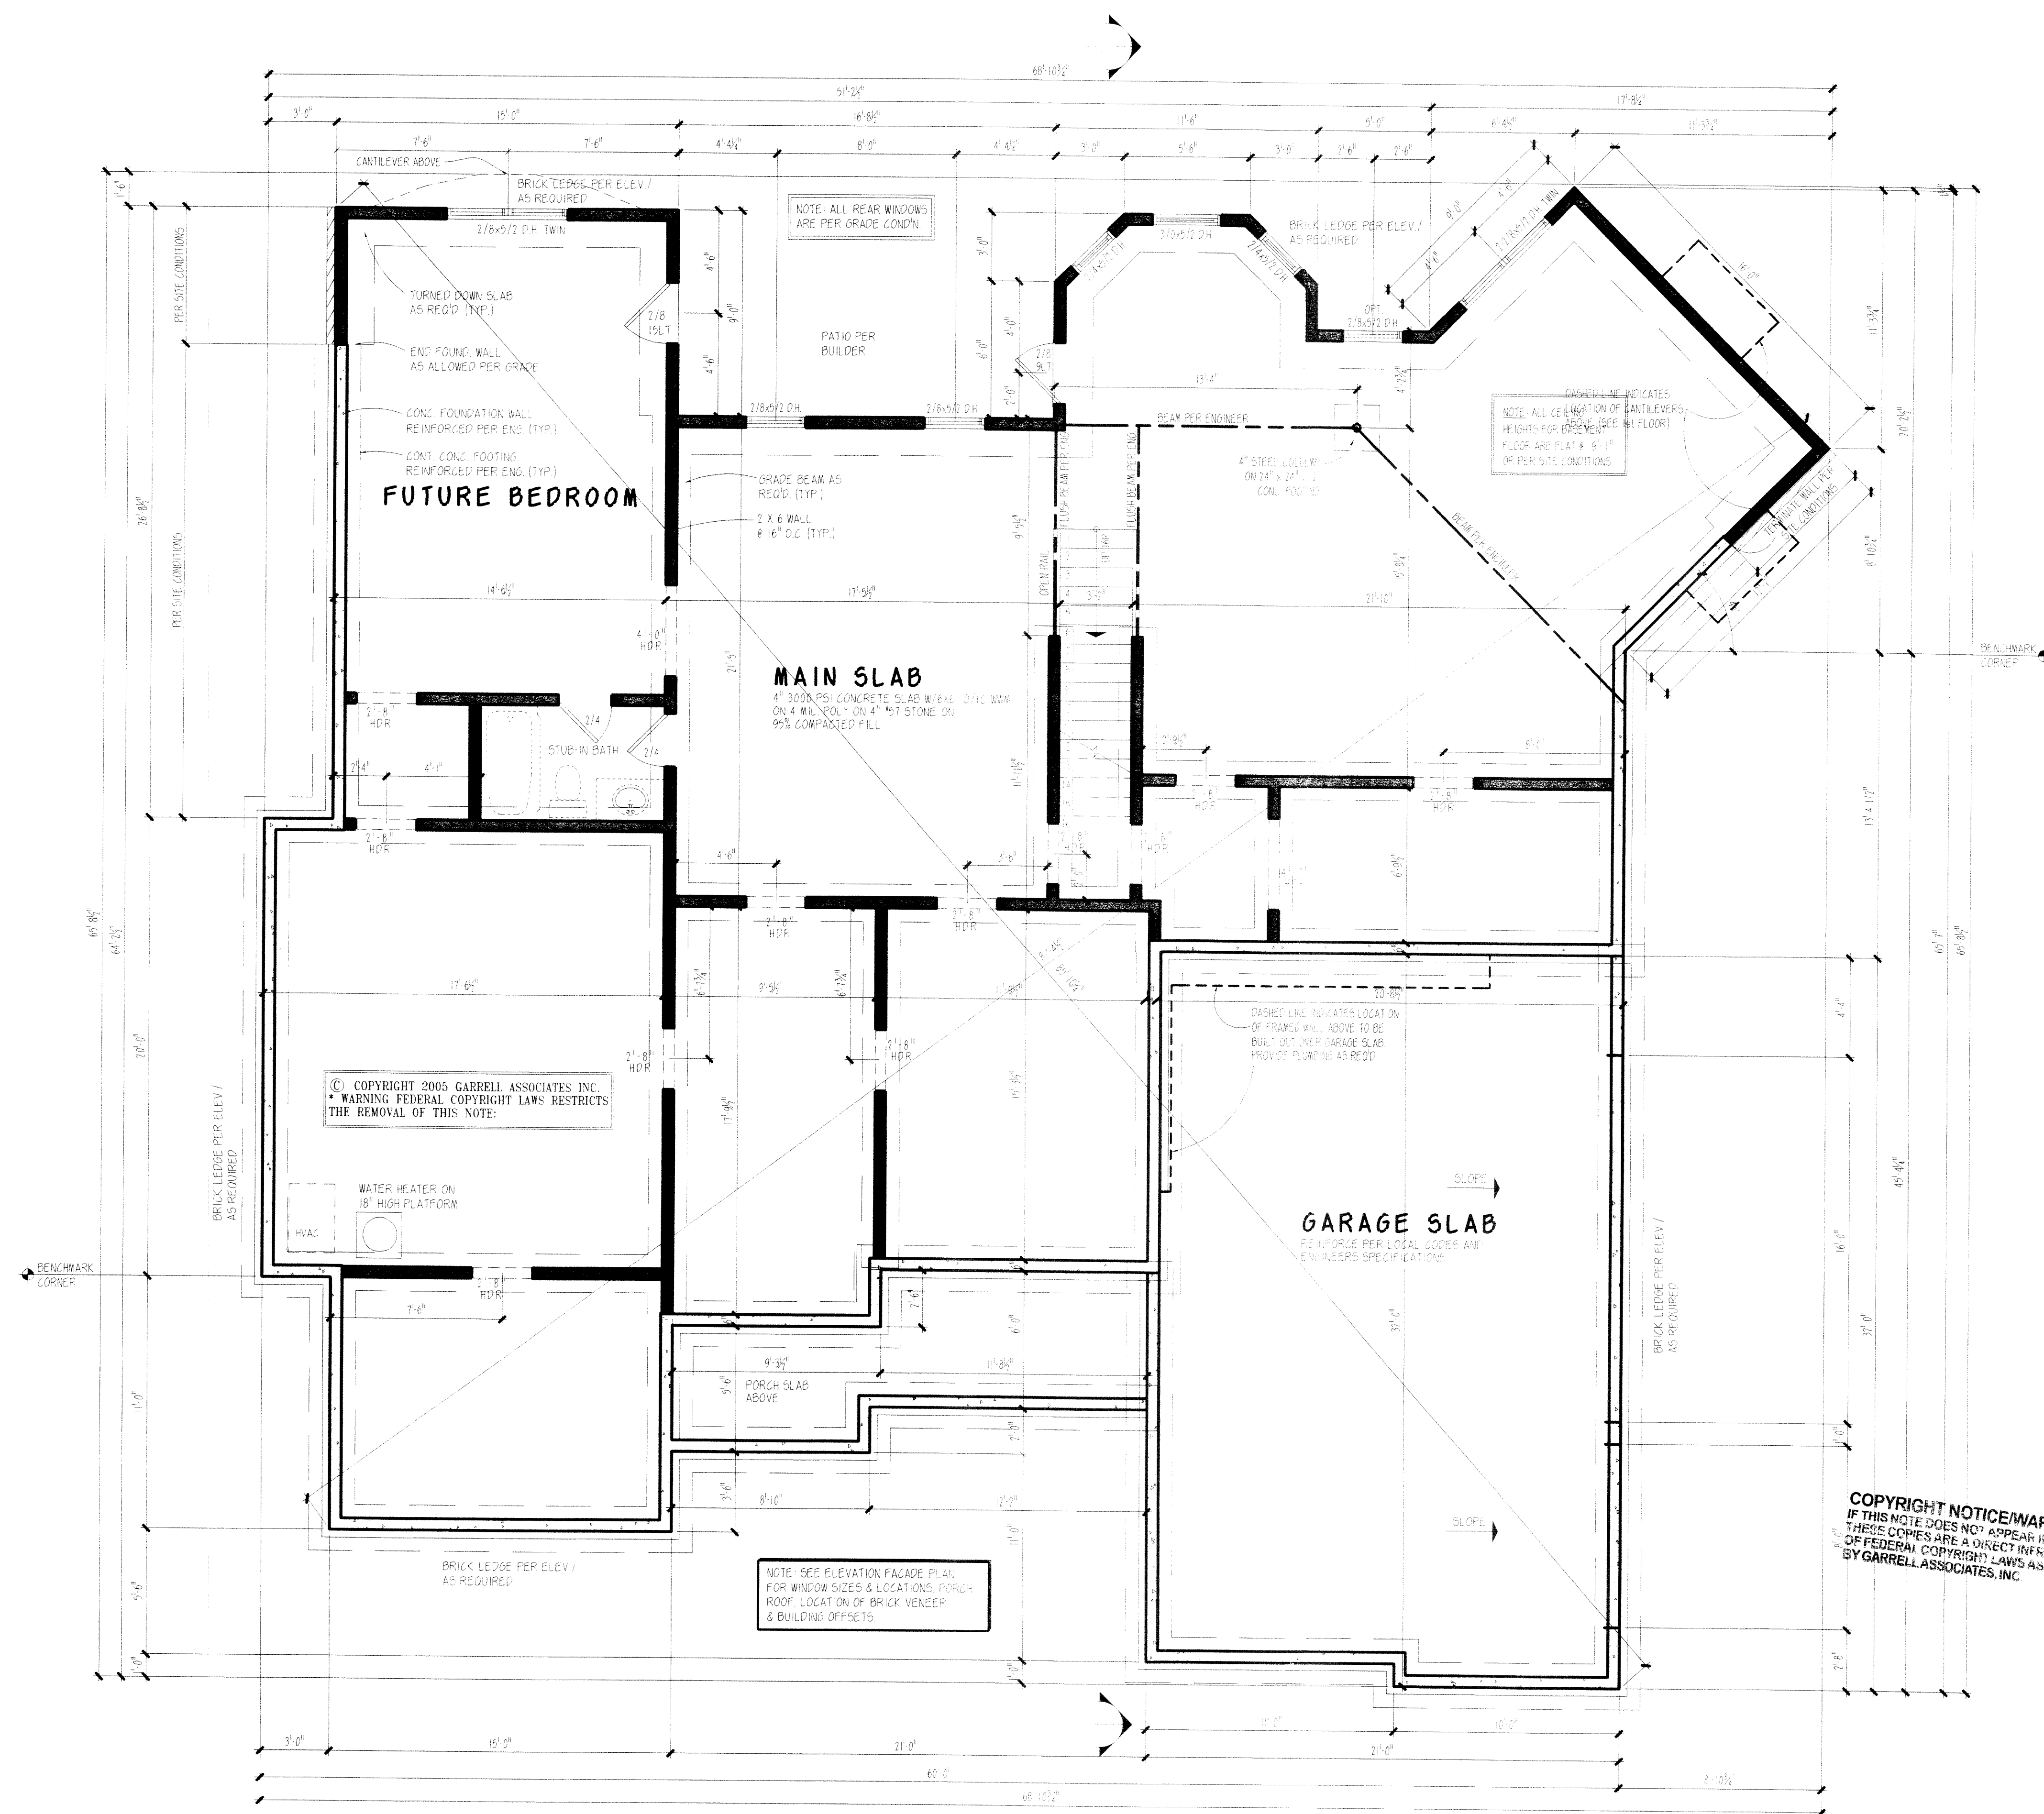

NOTE: ALL DOOR & WINDOW OPENINGS
ARE CENTERED ON WALL OR 6" FROM
CORNER UNLESS OTHERWISE SPECIFIED

NOTE: ALL DOOR & WINDOW OPENINGS
IN EXTERIOR WALLS OF BASEMENT
TO BE DETERMINED BY BUILDER
BASED ON SITE CONDITIONS

GENERAL NOTES

1. ALL WORK SHALL BE PERFORMED IN ACCORDANCE WITH ALL NATIONAL AND LOCAL CODES, REGULATIONS AND CADD 2000 INTERNATIONAL BUILDING CODE.
2. CONTRACTOR SHALL VERIFY ALL CONDITIONS AND DIMENSIONS AT THE SITE BEFORE BEGINNING CONSTRUCTION. ANY DISCREPANCIES SHALL BE REPORTED TO GARRELL ASSOCIATES, INC. FOR JUSTIFICATION OR CORRECTION BEFORE PROCEEDING WITH THE WORK. CONTRACTOR SHALL ASSUME RESPONSIBILITY FOR ERRORS THAT ARE NOT REPORTED.
3. ALL DIMENSIONS SHALL BE READ OR CALCULATED AND NEVER SLACKED.
4. ALL PORTIONS OF FOOTINGS ARE TO BE BELOW LOCAL FROST LINES AND MUST REST ON UNDISTURBED SOIL WITH ADEQUATE BEARING CAPACITY TO SUPPORT THE STRUCTURE. A LOCAL ENGINEER MUST BE CONSULTED FOR PROPER FOOTING AND REINFORCEMENT SIZES.
5. CONTRACTOR TO ENSURE COMPATIBILITY OF THE BUILDING WITH ALL SITE REQUIREMENTS.
6. REINFORCE FOUNDATION WALLS PER LOCAL CODES.
7. ALL FOUNDATION AND STRUCTURAL MEMBERS SHOULD BE VERIFIED AND STAMPED BY AN ENGINEER. THE CONTRACTOR IS RESPONSIBLE FOR THE ADJUSTMENT AND VERIFICATION OF ALL STRUCTURAL DETAILS AND CONDITIONS TO MEET ALL LOCAL CODES AND TO INSURE A WELL-CONSTRUCTED AND SAFE STRUCTURE.
8. ALL WOOD CONCRETE AND STEEL STRUCTURAL MEMBERS ARE TO MEET NATIONAL, STATE AND LOCAL BUILDING CODES.
9. ALL COLUMNS OR SOLID FRAMING SHALL BE DESIGNED TO CARRY AND TERMINATE LOADS THROUGH THE STRUCTURE TO FOUNDATION ELEMENTS THAT DISTRIBUTE THE LOADS TO FULL CAPACITY SOILS.
10. GARRELL ASSOCIATES ASSUMES NO LIABILITY FOR ANY HOME CONSTRUCTED FROM THIS PLAN.
11. THIS DESIGN LICENSE IS RELEASED FOR ONE (1) BUILDING STRUCTURE ONLY AND IS NOT TRANSFERABLE TO ANOTHER INDIVIDUAL OR COMPANY.
12. GARRELL ASSOCIATES, INC. IS THE SOLE OWNER OF THIS OR ANY DERIVATIVE MODIFICATION OF THIS COPYRIGHT PROTECTED PLAN.

COPYRIGHT NOTICE/WARNING
IF THIS NOTE DOES NOT APPEAR IN RED IN THESE COPIES ARE A DIRECT INFRINGEMENT OF FEDERAL COPYRIGHT LAWS AS SECURED BY GARRELL ASSOCIATES, INC.

NOTE: THE DESIGNS SPECIFIED IN THESE DRAWINGS ARE PROTECTED UNDER FEDERAL COPYRIGHT LAWS AND ARE NOT TO BE REPRODUCED OR USED IN ANY MANNER WITHOUT THE WRITTEN PERMISSION OF GARRELL ASSOCIATES, INC. © COPYRIGHT 2005 GARRELL ASSOCIATES, INC. THESE DRAWINGS AND ITS REPRODUCTIONS ARE THE PROPERTY OF GARRELL ASSOCIATES, INC. AND MAY NOT BE REPRODUCED, PUBLISHED OR USED IN ANY MANNER WITHOUT THE WRITTEN PERMISSION OF GARRELL ASSOCIATES, INC.

TRE'S MAISON

BASEMENT PLAN

2-23-01

REV. NO.	REV. DATE
1	4-7-05 TC

THIS COPYRIGHTED DESIGN IS THE SOLE PROPERTY OF GARRELL ASSOCIATES, INC. AND MAY NOT BE USED OR REPRODUCED WITHOUT THE EXPRESSED WRITTEN CONSENT OF GARRELL ASSOCIATES, INC.




CAUTION: ONLY A QUALIFIED DESIGNER, ARCHITECT, CONTRACTOR, OR STRUCTURAL ENGINEER SHOULD ATTEMPT TO MODIFY THIS PLAN.

01049

DRAWN	SHEET NO.
VD	B1

BASEMENT PLAN

SCALE: 1/4" = 1'-0"

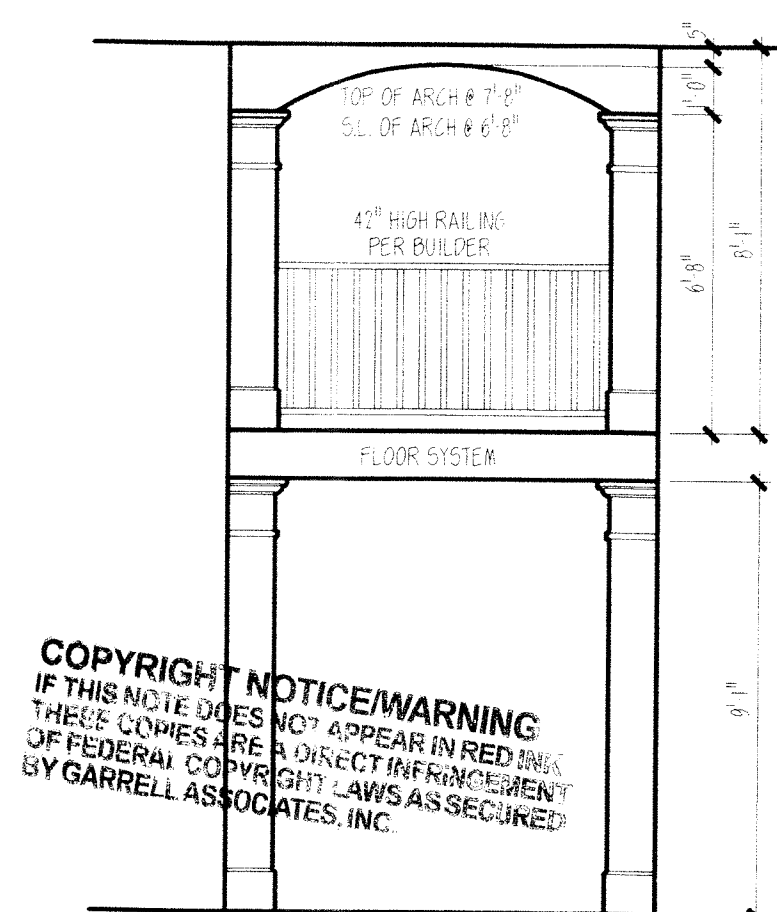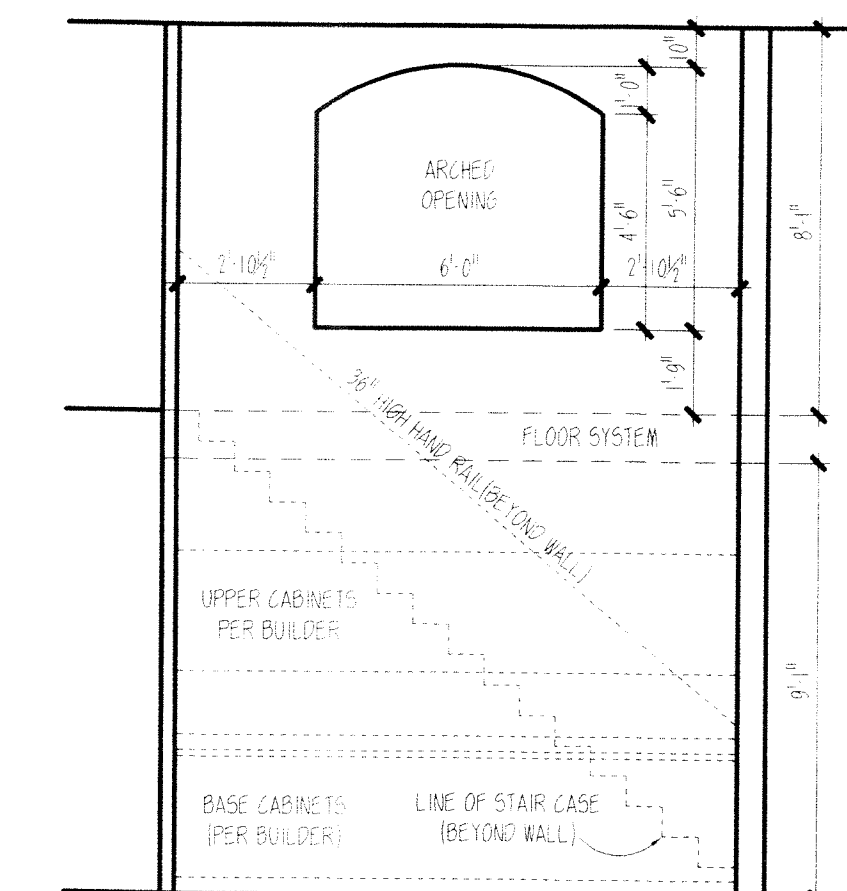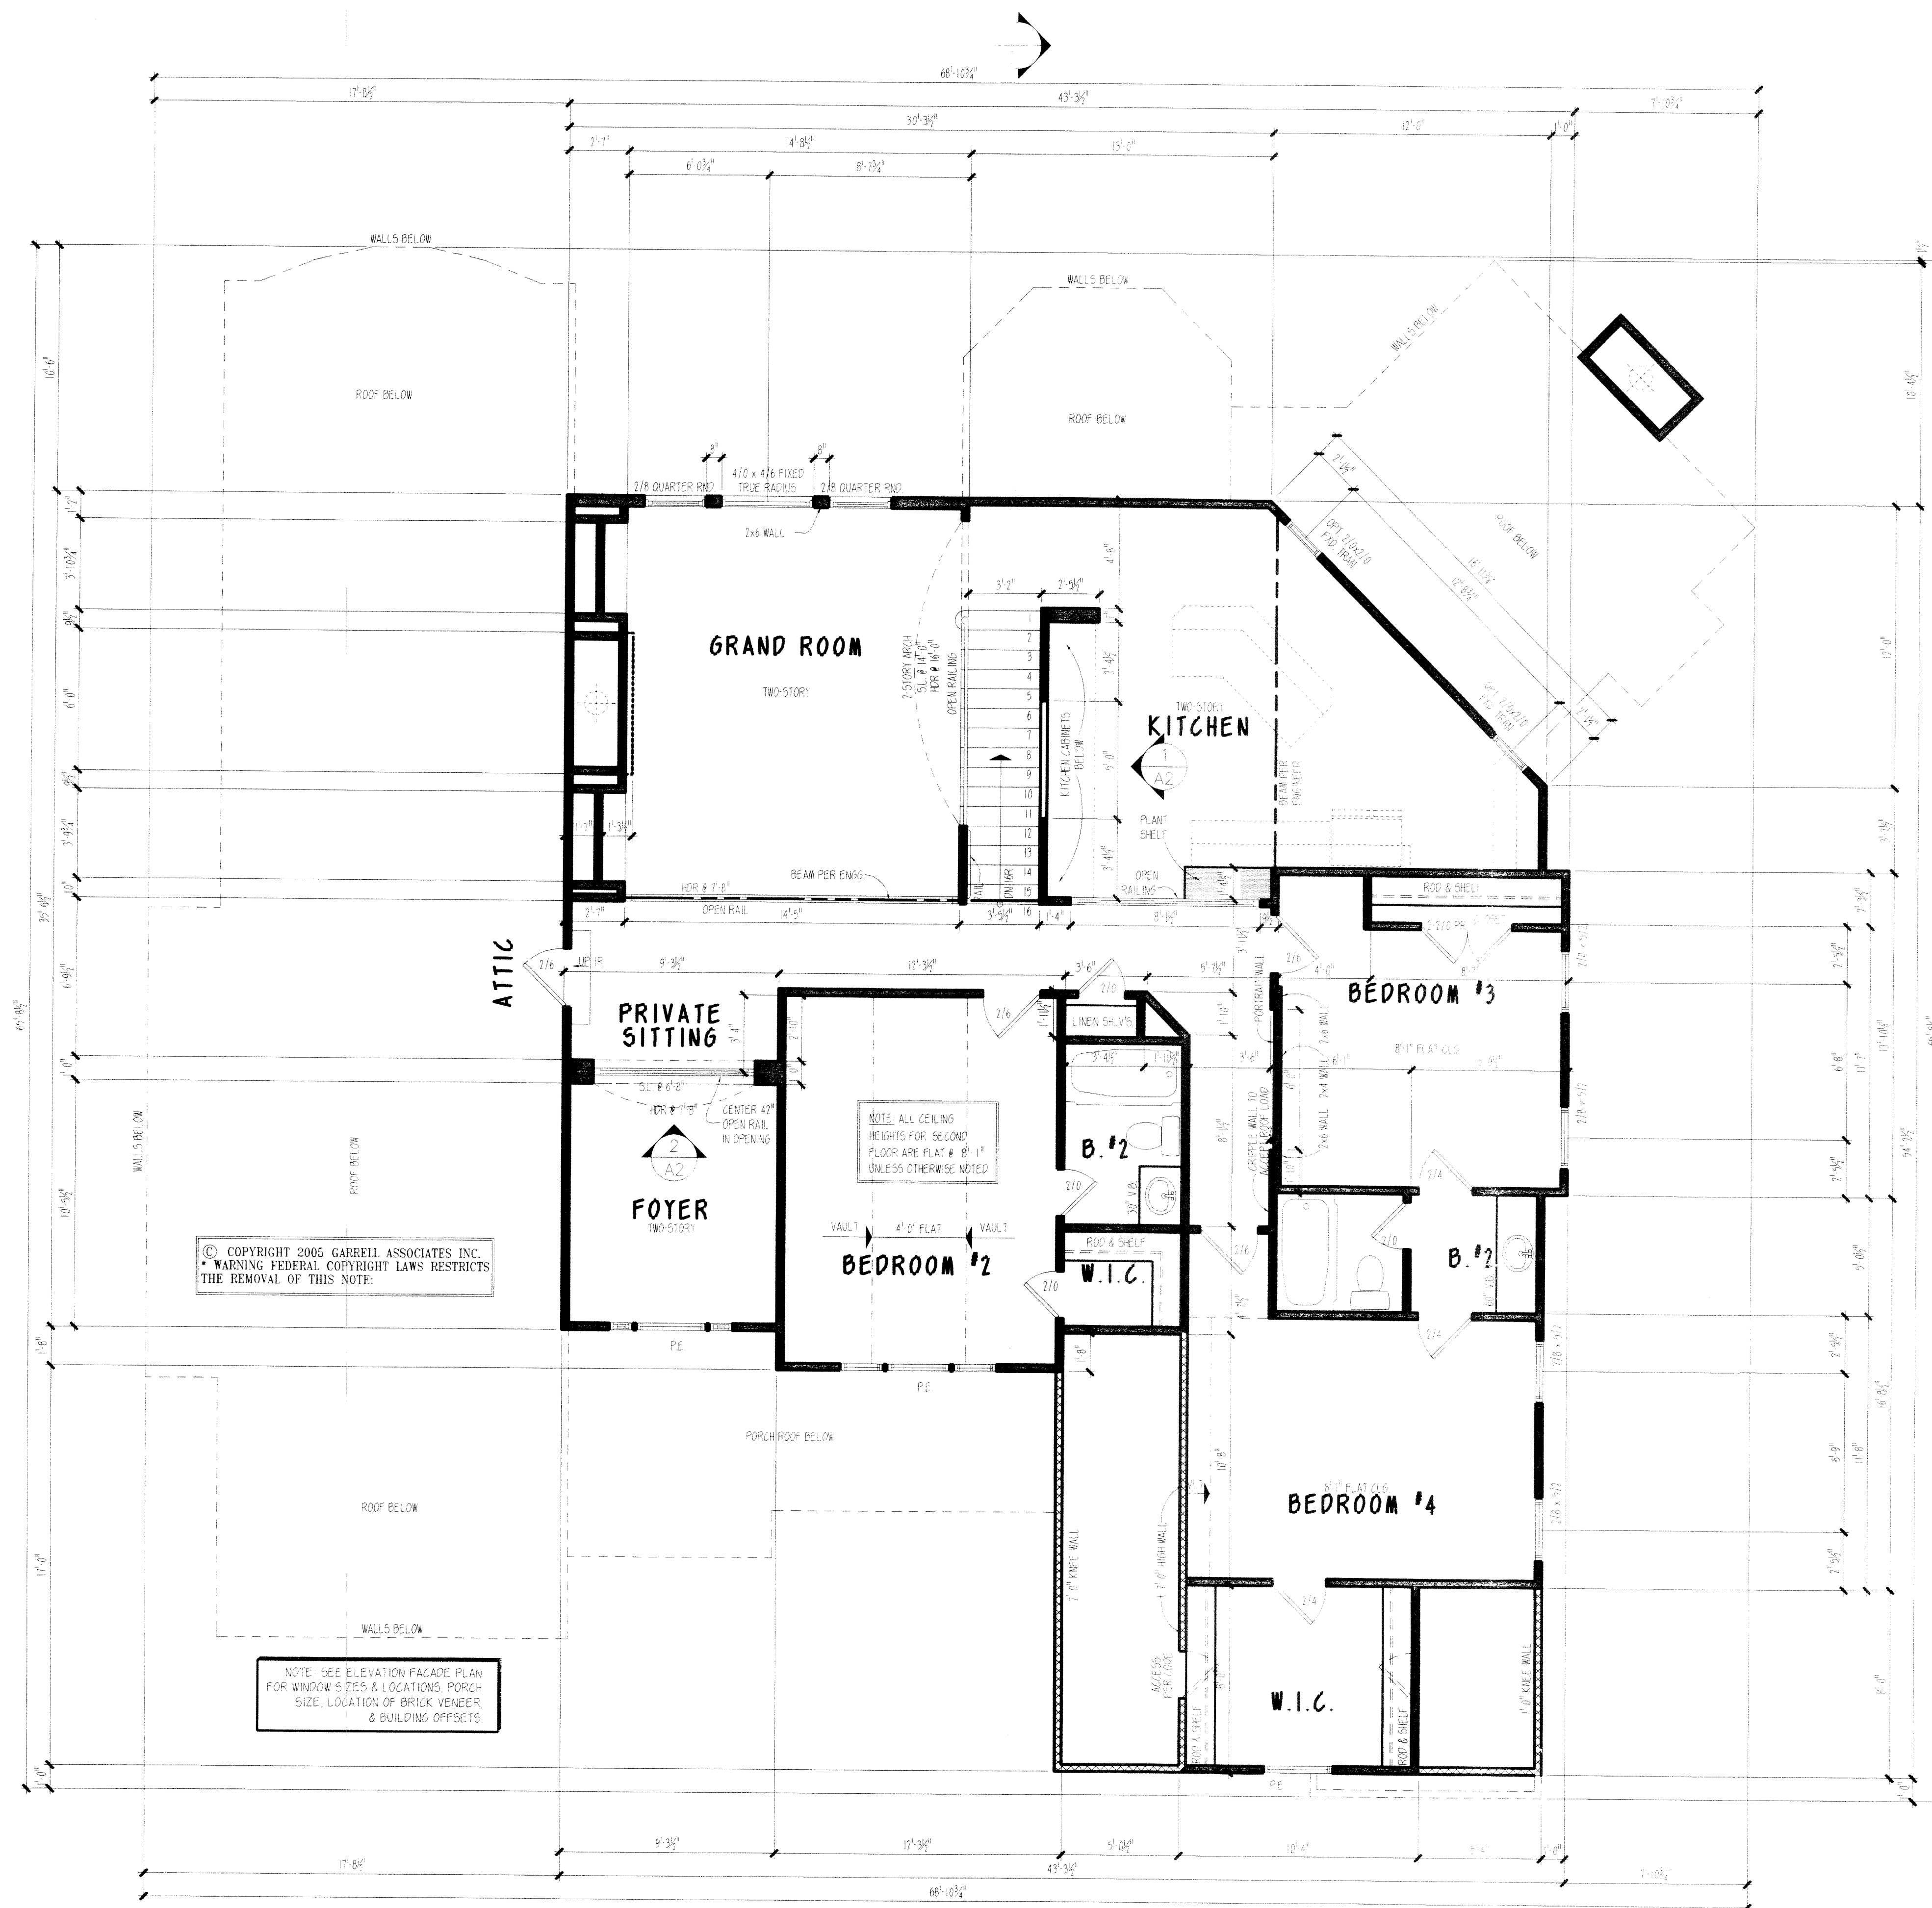

COPYRIGHT NOTICE/WARNING
IF THIS NOTE DOES NOT APPEAR IN RED INK, THESE DIMENSIONS ARE A DIRECT INFRINGEMENT OF FEDERAL COPYRIGHT LAWS AS SECURED BY GARRELL ASSOCIATES, INC.

GENERAL NOTES

1. ALL WORK SHALL BE PERFORMED IN ACCORDANCE WITH ALL NATIONAL AND LOCAL CODES, REGULATIONS AND ORDINANCES.
2. CONTRACTOR SHALL VERIFY ALL CONDITIONS AND DIMENSIONS AT THE SITE BEFORE BEGINNING CONSTRUCTION. ANY DISCREPANCIES SHALL BE REPORTED TO GARRELL ASSOCIATES, INC. FOR INVESTIGATION OF CORRECTION BEFORE PROCEEDING WITH THE WORK. CONTRACTOR SHALL ASSUME RESPONSIBILITY FOR ERRORS THAT ARE NOT REPORTED.
3. ALL DIMENSIONS SHALL BE READ OR CALCULATED AND KEPT ON FILE.
4. ALL PORTIONS OF FOOTINGS ARE TO BE BELOW LOCAL FLOOD LINES AND MUST REST ON UNDISTURBED SOIL WITH ADEQUATE BEARING CAPACITY TO SUPPORT THE STRUCTURE. A LOCAL ENGINEER MUST BE CONSULTED FOR PROPER FOOTING AND REINFORCEMENT SIZES.
5. CONTRACTOR TO ENSURE COMPATIBILITY OF THE BUILDING WITH ALL SITE REQUIREMENTS.
6. REINFORCE FOUNDATION WALLS PER LOCAL CODES.
7. ALL FOUNDATION AND STRUCTURAL MEMBERS SHOULD BE VERIFIED AND STAMPED BY AN ENGINEER. THE CONTRACTOR IS RESPONSIBLE FOR THE ADJUSTMENT AND VERIFICATION OF ALL STRUCTURAL DETAILS AND CONDITIONS TO MEET ALL LOCAL CODES AND TO INSURE A WELL CONSTRUCTED AND SAFE STRUCTURE.
8. ALL WOOD, CONCRETE AND STEEL STRUCTURAL MEMBERS ARE TO MEET NATIONAL, STATE AND LOCAL BUILDING CODES.
9. ALL COLUMNS OR SOLID FRAMING SHALL BE DESIGNED TO CARRY AND TERMINATE LOADS THROUGH THE STRUCTURE TO FOUNDATION ELEMENTS THAT DISTRIBUTE THE LOADS TO FULL CAPACITY SOILS.
10. GARRELL ASSOCIATES ASSUMES NO LIABILITY FOR ANY WORK CONSTRUCTED FROM THIS PLAN.
11. THIS DESIGN LICENSE IS RELEASED FOR ONE (1) BUILDING STRUCTURE ONLY AND IS NOT TRANSFERABLE TO ANOTHER INDIVIDUAL OR COMPANY.
12. GARRELL ASSOCIATES, INC. IS THE SOLE OWNER OF THIS OR ANY DERIVATIVE MODIFICATION OF THIS COPYRIGHT PROTECTED PLAN.

PLAN BOOK

GARRELL ASSOCIATES, INC.
790 PEACHTREE IND. BLVD.
SUITE 200, SUWANEE, GA 30024
WWW.GARRELLASSOCIATES.COM

TRE'S MAISON
SECOND FLOOR PLAN

2-23-01

REV. NO.	REV. DATE
1	4-7-09 TC


THIS COPYRIGHTED DESIGN IS THE SOLE PROPERTY OF GARRELL ASSOCIATES, INC. AND MAY NOT BE USED OR REPRODUCED WITHOUT THE EXPRESSED WRITTEN CONSENT OF GARRELL ASSOCIATES, INC.

CAUTION: ONLY A QUALIFIED DESIGNER, ARCHITECT, CONTRACTOR, OR STRUCTURAL ENGINEER SHOULD ATTEMPT TO MODIFY THIS PLAN.

01049

DRAWN SHEET NO

VD A2

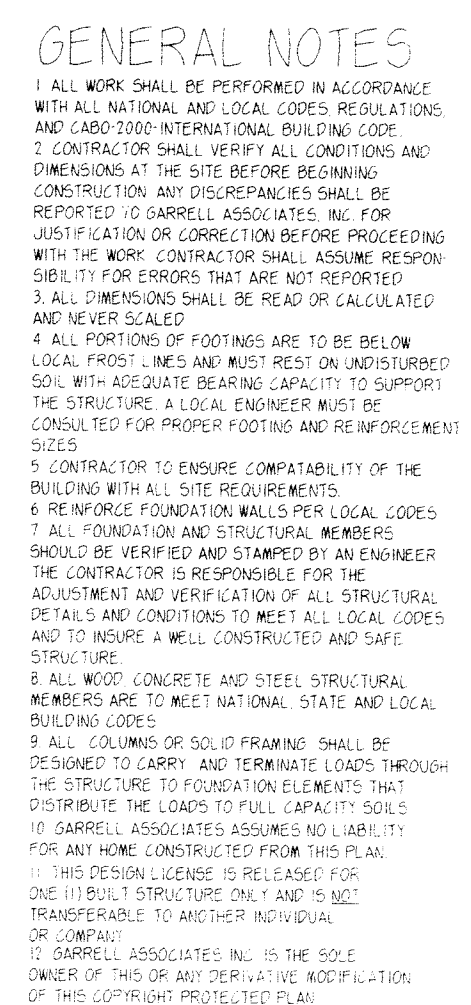


NOTE: THE DESIGNS PRINTED IN THESE DRAWINGS ARE PROTECTED UNDER FEDERAL COPYRIGHT LAW AND ARE NOT TO BE REPRODUCED OR TRANSMITTED IN ANY FORM OR BY ANY MEANS, ELECTRONIC OR MECHANICAL, INCLUDING PHOTOCOPYING, RECORDING, OR BY ANY INFORMATION STORAGE AND RETRIEVAL SYSTEM, WITHOUT PERMISSION IN WRITING FROM GABRELL ASSOCIATES, INC.

FIRST FLOOR PLAN

THIS PLAN

100

*CALCULATED PER I.R.C. INDUSTR. STD. TO OUTSIDE FACE OF STUD. STAIRS & 2-STORY COUNTED ONK

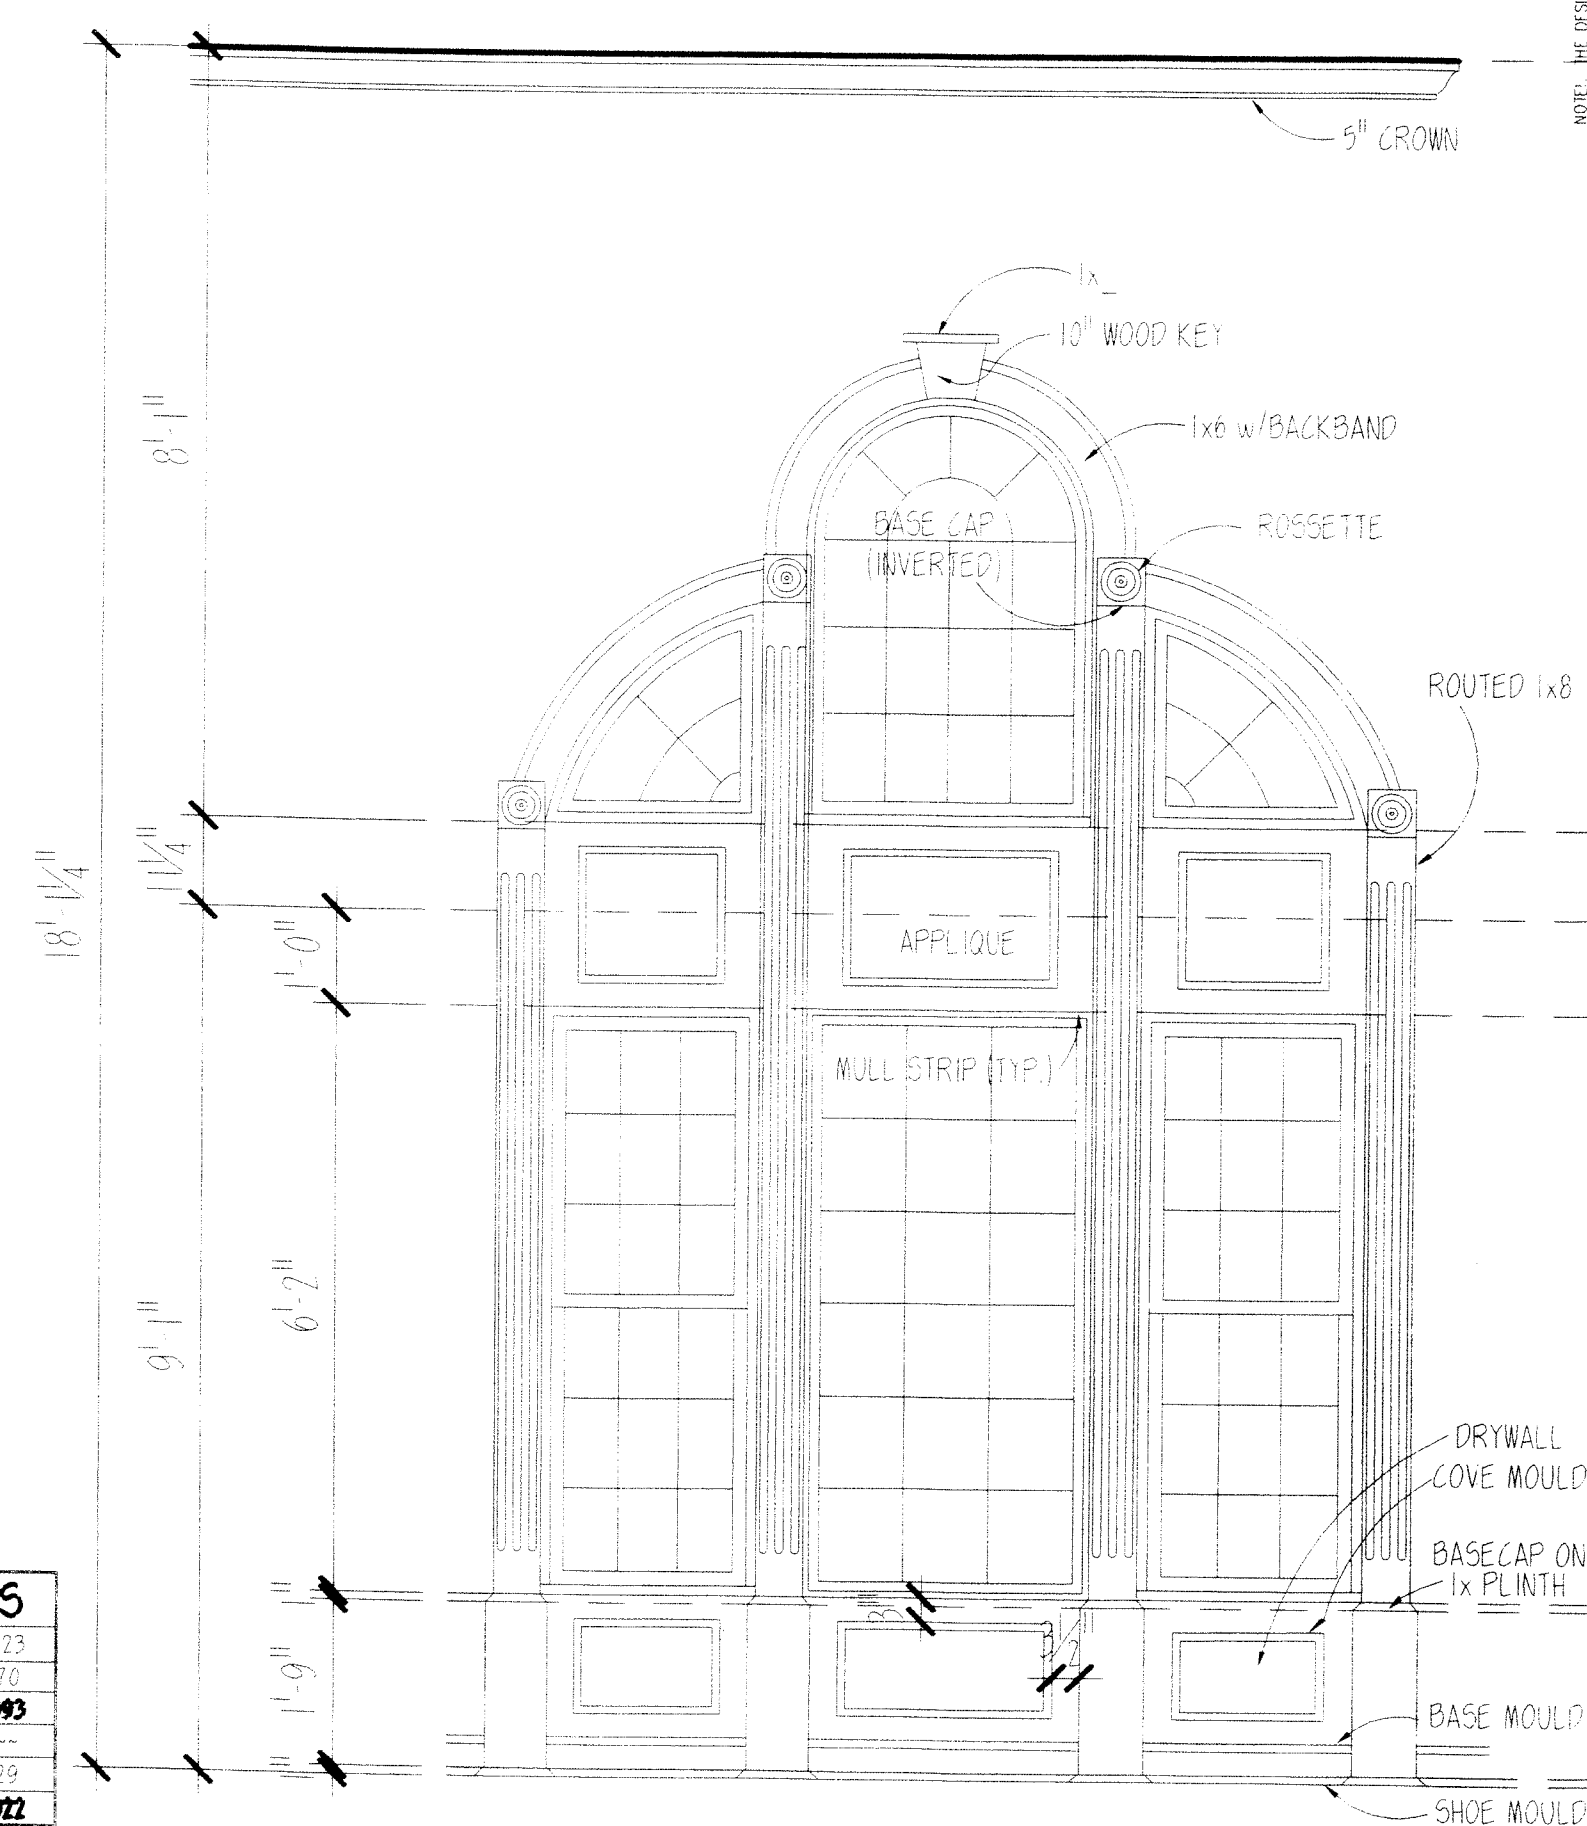

TRIM DETAIL

SCALE: NTS

VD

A1

Highland Ridge

PLAN BOOK

GARRELL ASSOCIATES INC.
790 PEACHTREE IND. BLVD.
SUITE 200, SUWANEE, GA 30024
PHONE (770) 614-2500
WWW.GARRELLASSOCIATES.COM

TRE'S MAISON
FRONT ELEVATION

2-23-01

REV NO	REV DATE
1	4-7-05 TC

THIS COPYRIGHTED DESIGN IS THE SOLE PROPERTY OF GARRELL ASSOCIATES, INC. AND MAY NOT BE USED OR REPRODUCED WITHOUT THE EXPRESSED WRITTEN CONSENT OF GARRELL ASSOCIATES, INC.


CAUTION: ONLY A QUALIFIED DESIGNER, ARCHITECT, CONTRACTOR, OR STRUCTURAL ENGINEER SHOULD ATTEMPT TO MODIFY THIS PLAN.

01049


DRAWN SHEET NO

VD

E1

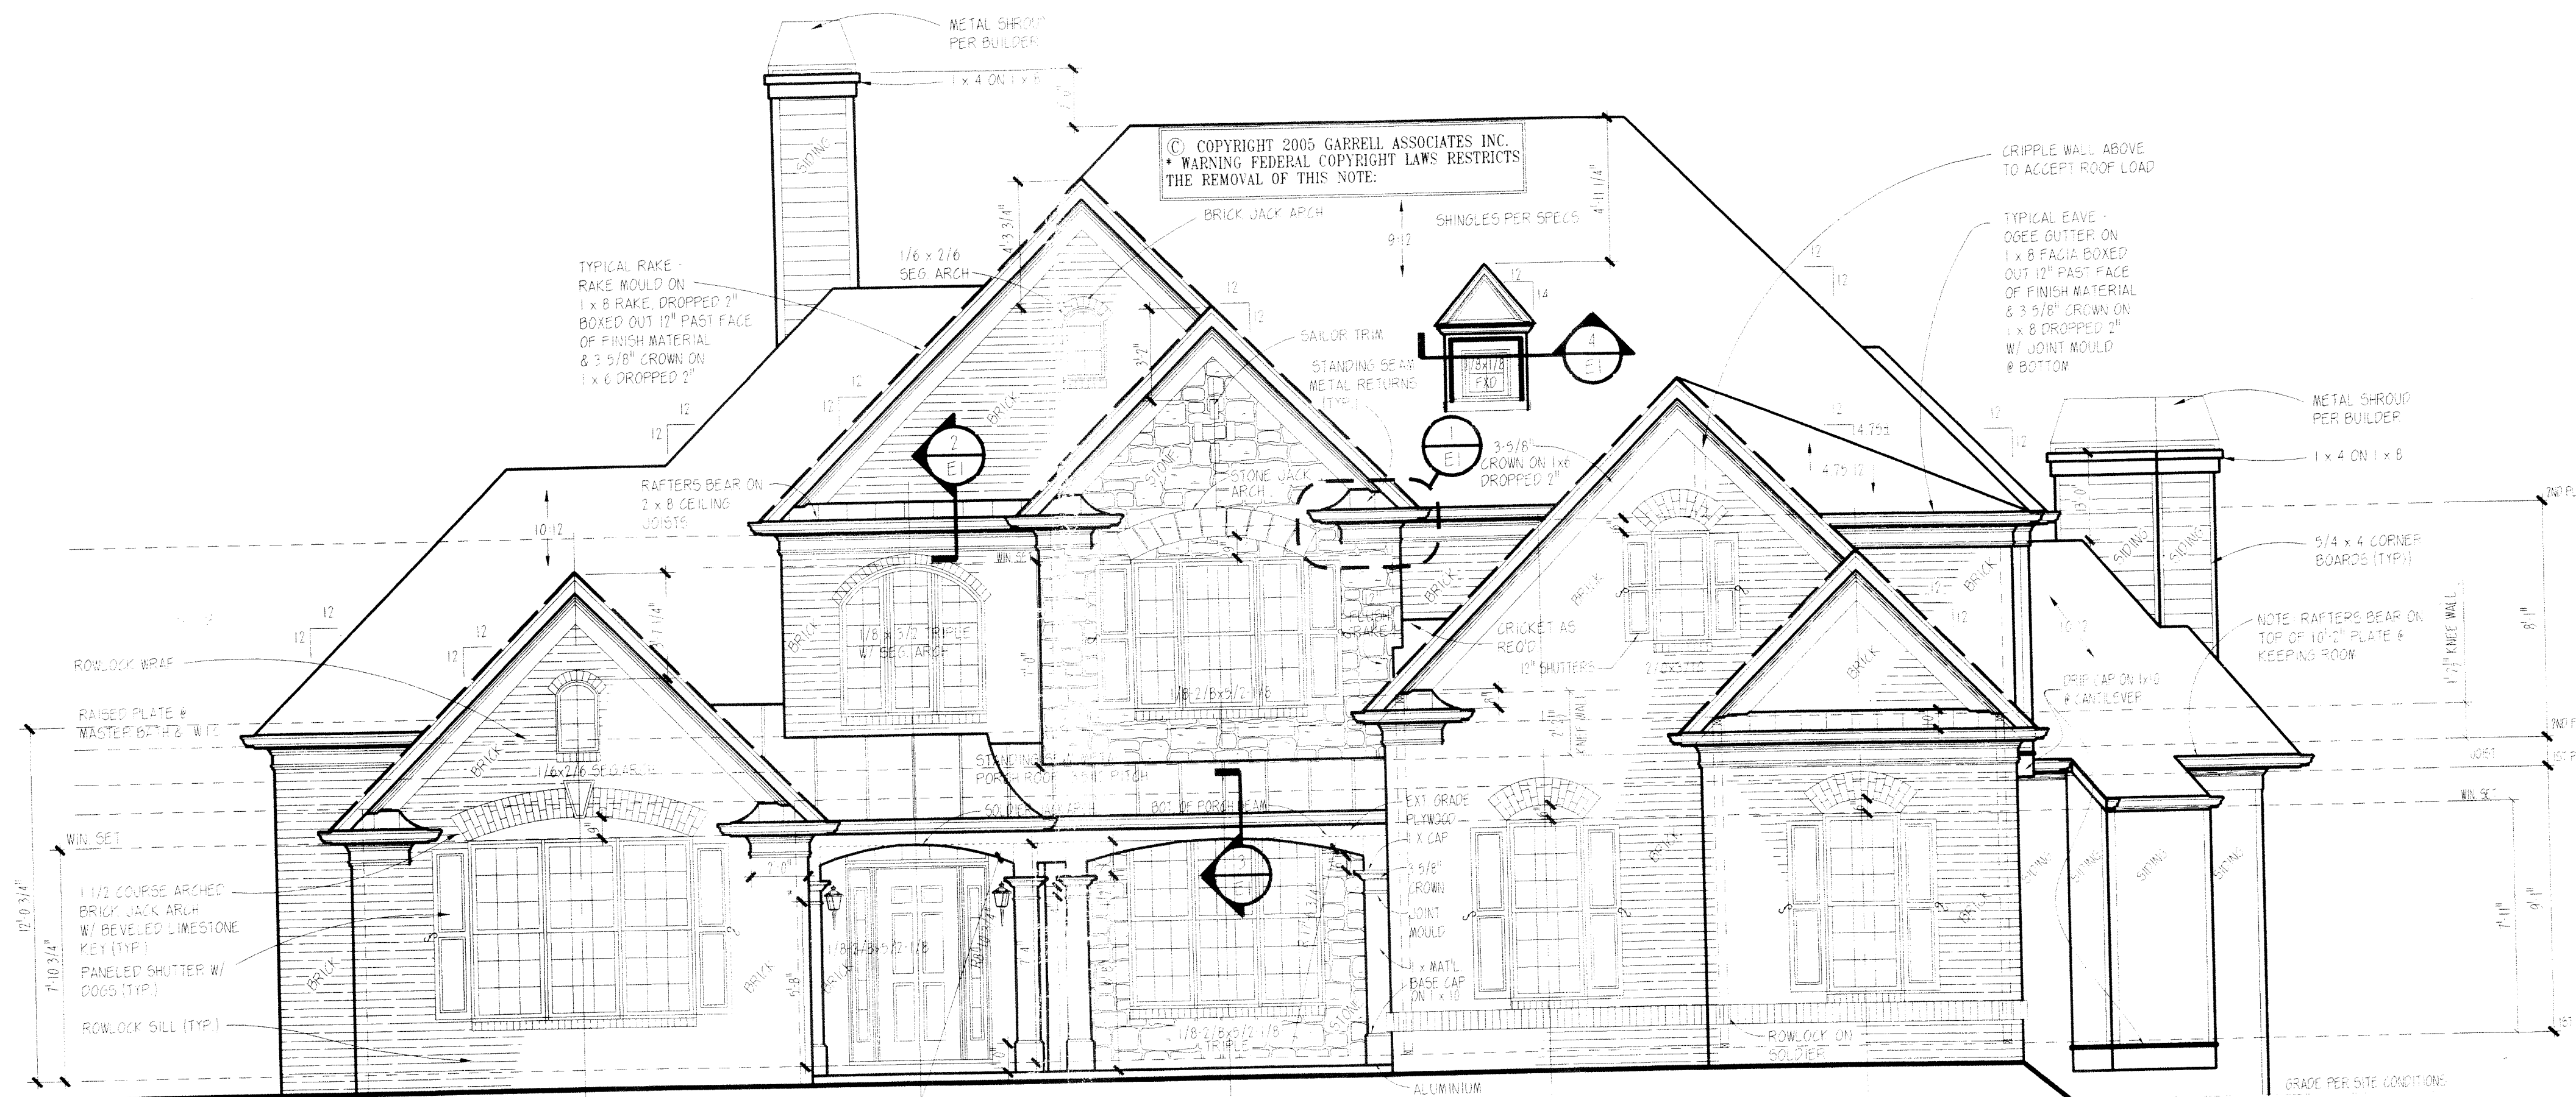

1 FRONT ELEVATION

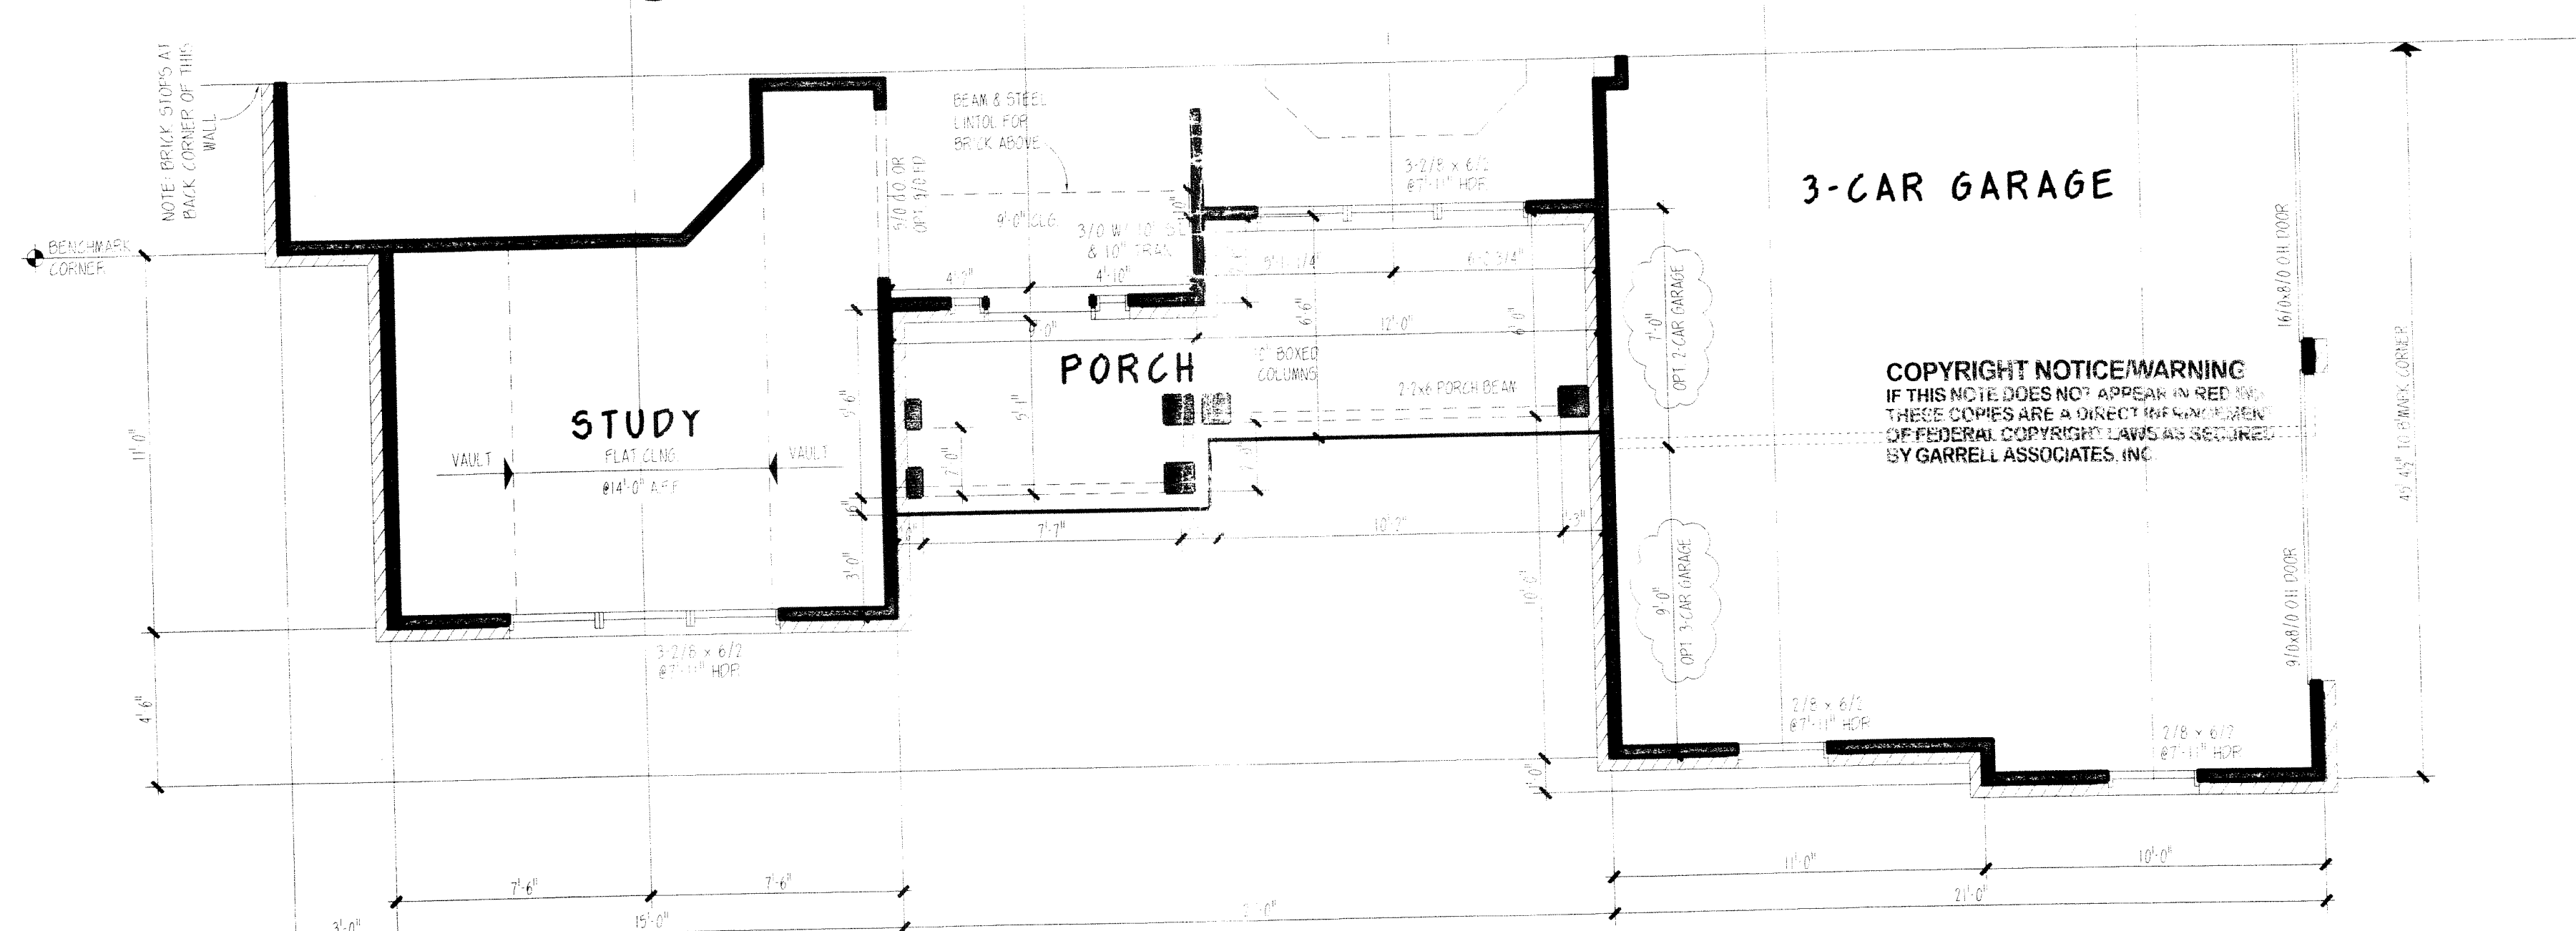

2 FACADE PLAN

COLOR PACKAGE

BRICK
SIDING
TRIM
SHUTTERS
METAL ROOFING
SHINGLE ROOF

BUILDER PLEASE NOTE: REUSE FEE


UNLESS RENEWED IN WRITING, THE LICENSE TO BUILD FROM THIS GARRELL ASSOCIATES, INC. COPYRIGHT PROTECTED PLAN EXPIRES ONE (1) YEAR FROM THE DATE BELOW. IT IS UNLAWFUL TO PRINT OR BUILD FROM THIS PLAN AFTER EXPIRATION DATE. RENEWAL OR REUSE FEE MAY APPLY.

PLAN ISSUED TO _____ SIGNED _____


PHONE _____ LOT _____

SIGNED _____ (GARRELL ASSOCIATES, INC. REP.)


ISSUE DATE _____ (NO BLACK INK)

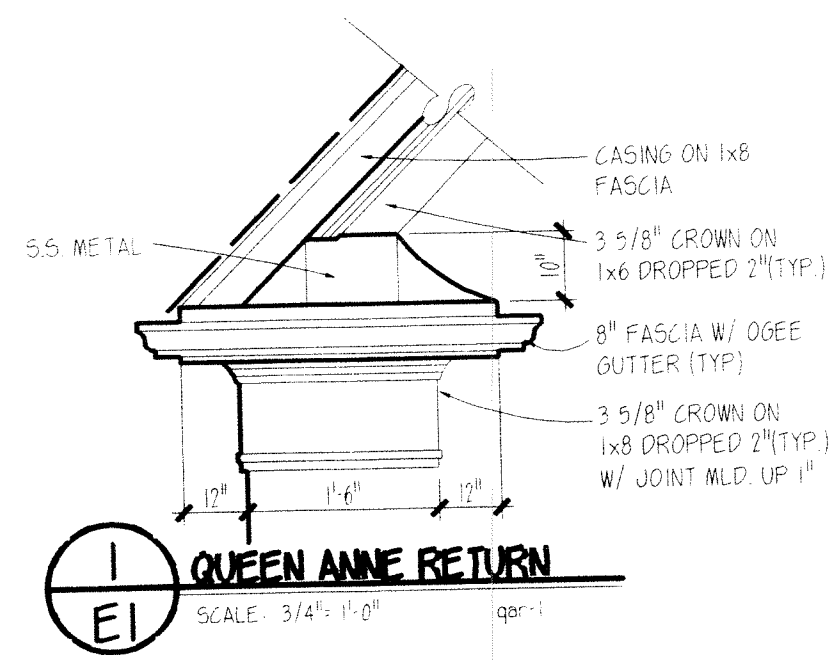


1 QUEEN ANNE RETURN

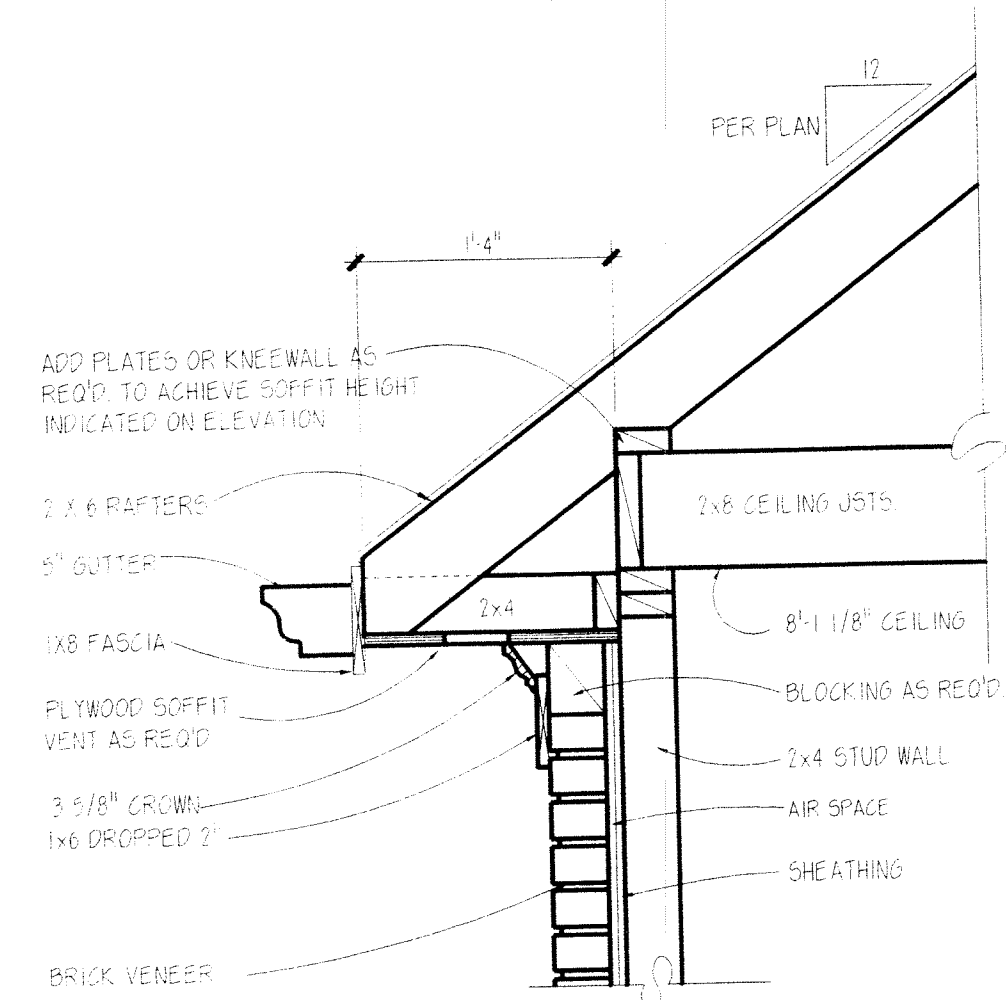

2 CORNICE W/ BRICK

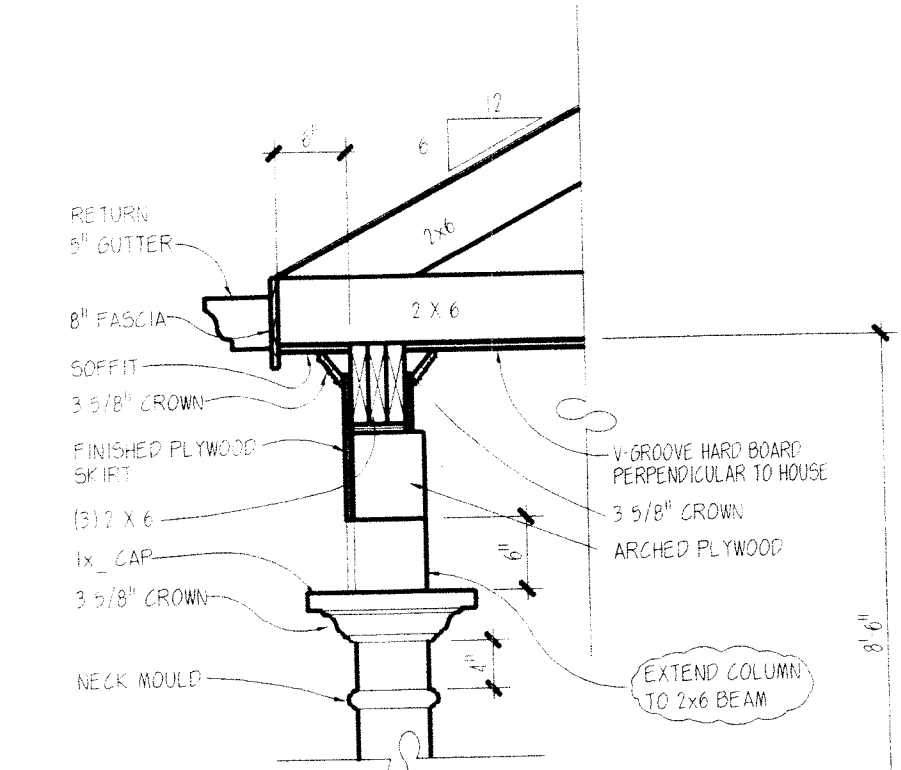

3 PORCH ROOF DETAIL

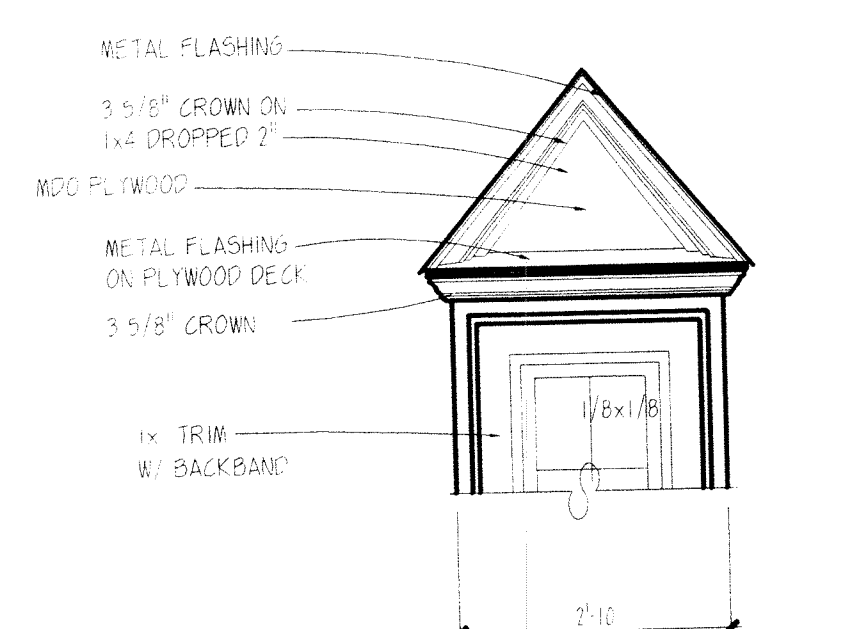


4 DORMER DETAIL

GENERAL NOTES

1. ALL WORK SHALL BE PERFORMED IN ACCORDANCE WITH ALL NATIONAL AND LOCAL CODES, REGULATIONS, AND CARPENTERS INTERNATIONAL BUILDING CODES.
2. CONTRACTOR SHALL VERIFY ALL CONDITIONS AND DIMENSIONS AT THE SITE BEFORE BEGINNING CONSTRUCTION. ANY DISCREPANCIES SHALL BE REPORTED TO GARRELL ASSOCIATES, INC. FOR JUSTIFICATION OR CORRECTION BEFORE PROCEEDING WITH THE WORK. CONTRACTOR SHALL ASSUME RESPONSIBILITY FOR ERRORS THAT ARE NOT REPORTED.
3. ALL DIMENSIONS SHALL BE READ OR CALCULATED AND NEVER SCALED.
4. ALL PORTIONS OF FOOTINGS ARE TO BE BELIEVED LOCAL PROXY LINES AND MUST BE SET ON UNDISTURBED SOIL WITH ADEQUATE BEARING CAPACITY TO SUPPORT LOADS. A LOCAL ENGINEER MUST BE CONSULTED FOR PROPER FOOTING AND REINFORCEMENT SIZES.
5. CONTRACTOR TO ENSURE COMPATIBILITY OF THE BUILDING WITH ALL SITE REQUIREMENTS.
6. REINFORCED FOUNDATION WALLS PER LOCAL CODES. ALL FOUNDATION AND STRUCTURAL MEMBERS SHOULD BE VERIFIED AND STAMPED BY AN ENGINEER. THE CONTRACTOR IS RESPONSIBLE FOR THE ADJUSTMENT AND VERIFICATION OF ALL STRUCTURAL DETAILS AND CONDITIONS TO MEET ALL LOCAL CODES AND TO INSURE A WELL CONSTRUCTED AND SAFE STRUCTURE.
7. ALL WOOD CONCRETE AND STEEL STRUCTURAL MEMBERS ARE TO MEET NATIONAL, STATE AND LOCAL BUILDING CODES.
8. ALL COLUMNS OR SOLID FRAMING SHALL BE DESIGNED TO APPLY AND TERMINATE LOADS THROUGH THE STRUCTURE TO FOUNDATION ELEMENTS THAT DISTRIBUTE THE LOADS TO FULL CAPACITY SOILS.
9. GARRELL ASSOCIATES ASSUMES NO LIABILITY FOR ANY HOME CONSTRUCTED FROM THIS PLAN.
10. THIS DESIGN LICENSE IS RELEASED FOR ONE (1) BUILD STRUCTURE ONLY AND IS NOT TRANSFERABLE TO ANOTHER INDIVIDUAL OR COMPANY.
11. GARRELL ASSOCIATES, INC. IS THE SOLE OWNER OF THIS OR ANY DERIVATIVE MODIFICATION OF THIS COPYRIGHT PROTECTED PLAN.

COPYRIGHT NOTICE/WARNING
IF THIS NOTE DOES NOT APPEAR IN RED INK, THESE COPIES ARE A DIRECT REPRODUCTION OF FEDERAL COPYRIGHT LAWS AS SECURED BY GARRELL ASSOCIATES, INC.

SYMBOL	DESCRIPTION
	DUPLEX OUTLET (GROUNDED TYPE)
	WEATHER PROOF DUPLEX OUTLET (GFI)
	WALL SWITCH CONTROLLED DUPLEX OUTLET
	SWITCHED OUTLET
	ABOVE COUNTER LOCATION
	FLUSH FLOOR WALL SWITCH CONTROLLED DUPLEX OUTLET (OWNER VERIFY LOCATION)
	220 VOLT OUTLET OR CONNECTION
	TELEVISION ANTENNA/CABLE OUTLET
	TELEPHONE OUTLET LOCATION
	DOOR CHIME LOCATION
	120 VOLT JUNCTION BOX
	SINGLE POLE WALL SWITCH
	SINGLE POLE WALL SWITCH WITH DIMMER
	3-WAY WALL SWITCH
	3-WAY WALL SWITCH WITH DIMMER
	CEILING MOUNTED & SUSPENDED LIGHT FIXTURE
	WALL BRACKET MOUNTED LIGHT FIXTURE
	SUSPENDED CEILING MOUNTED LIGHT FIXTURE (PENDANT)
	RECESSED DIRECTIONAL CEILING LIGHT FIXTURE
	RECESSED CEILING LIGHT FIXTURE
	RECESSED LIGHT FOR WET AREA
	RECESSED WALL WASHER
	RECESSED PIN LIGHT
	ONE TUBE UNDER COUNTER FLUORESCENT LIGHT
	EXTERIOR CAST ALUMINUM FLOOD LIGHTS
	CEILING MOUNTED FAN - PADDLE
	CEILING MOUNTED FAN - EXHAUST
	CEILING MOUNTED FAN AND HEATER
	PORCELAIN LAMPHOLDER
	DOOR BELL BUTTON
	SMOKE DETECTOR
	THERMOSTAT
	AUTOMATIC GARAGE DOOR OPENER OUTLET

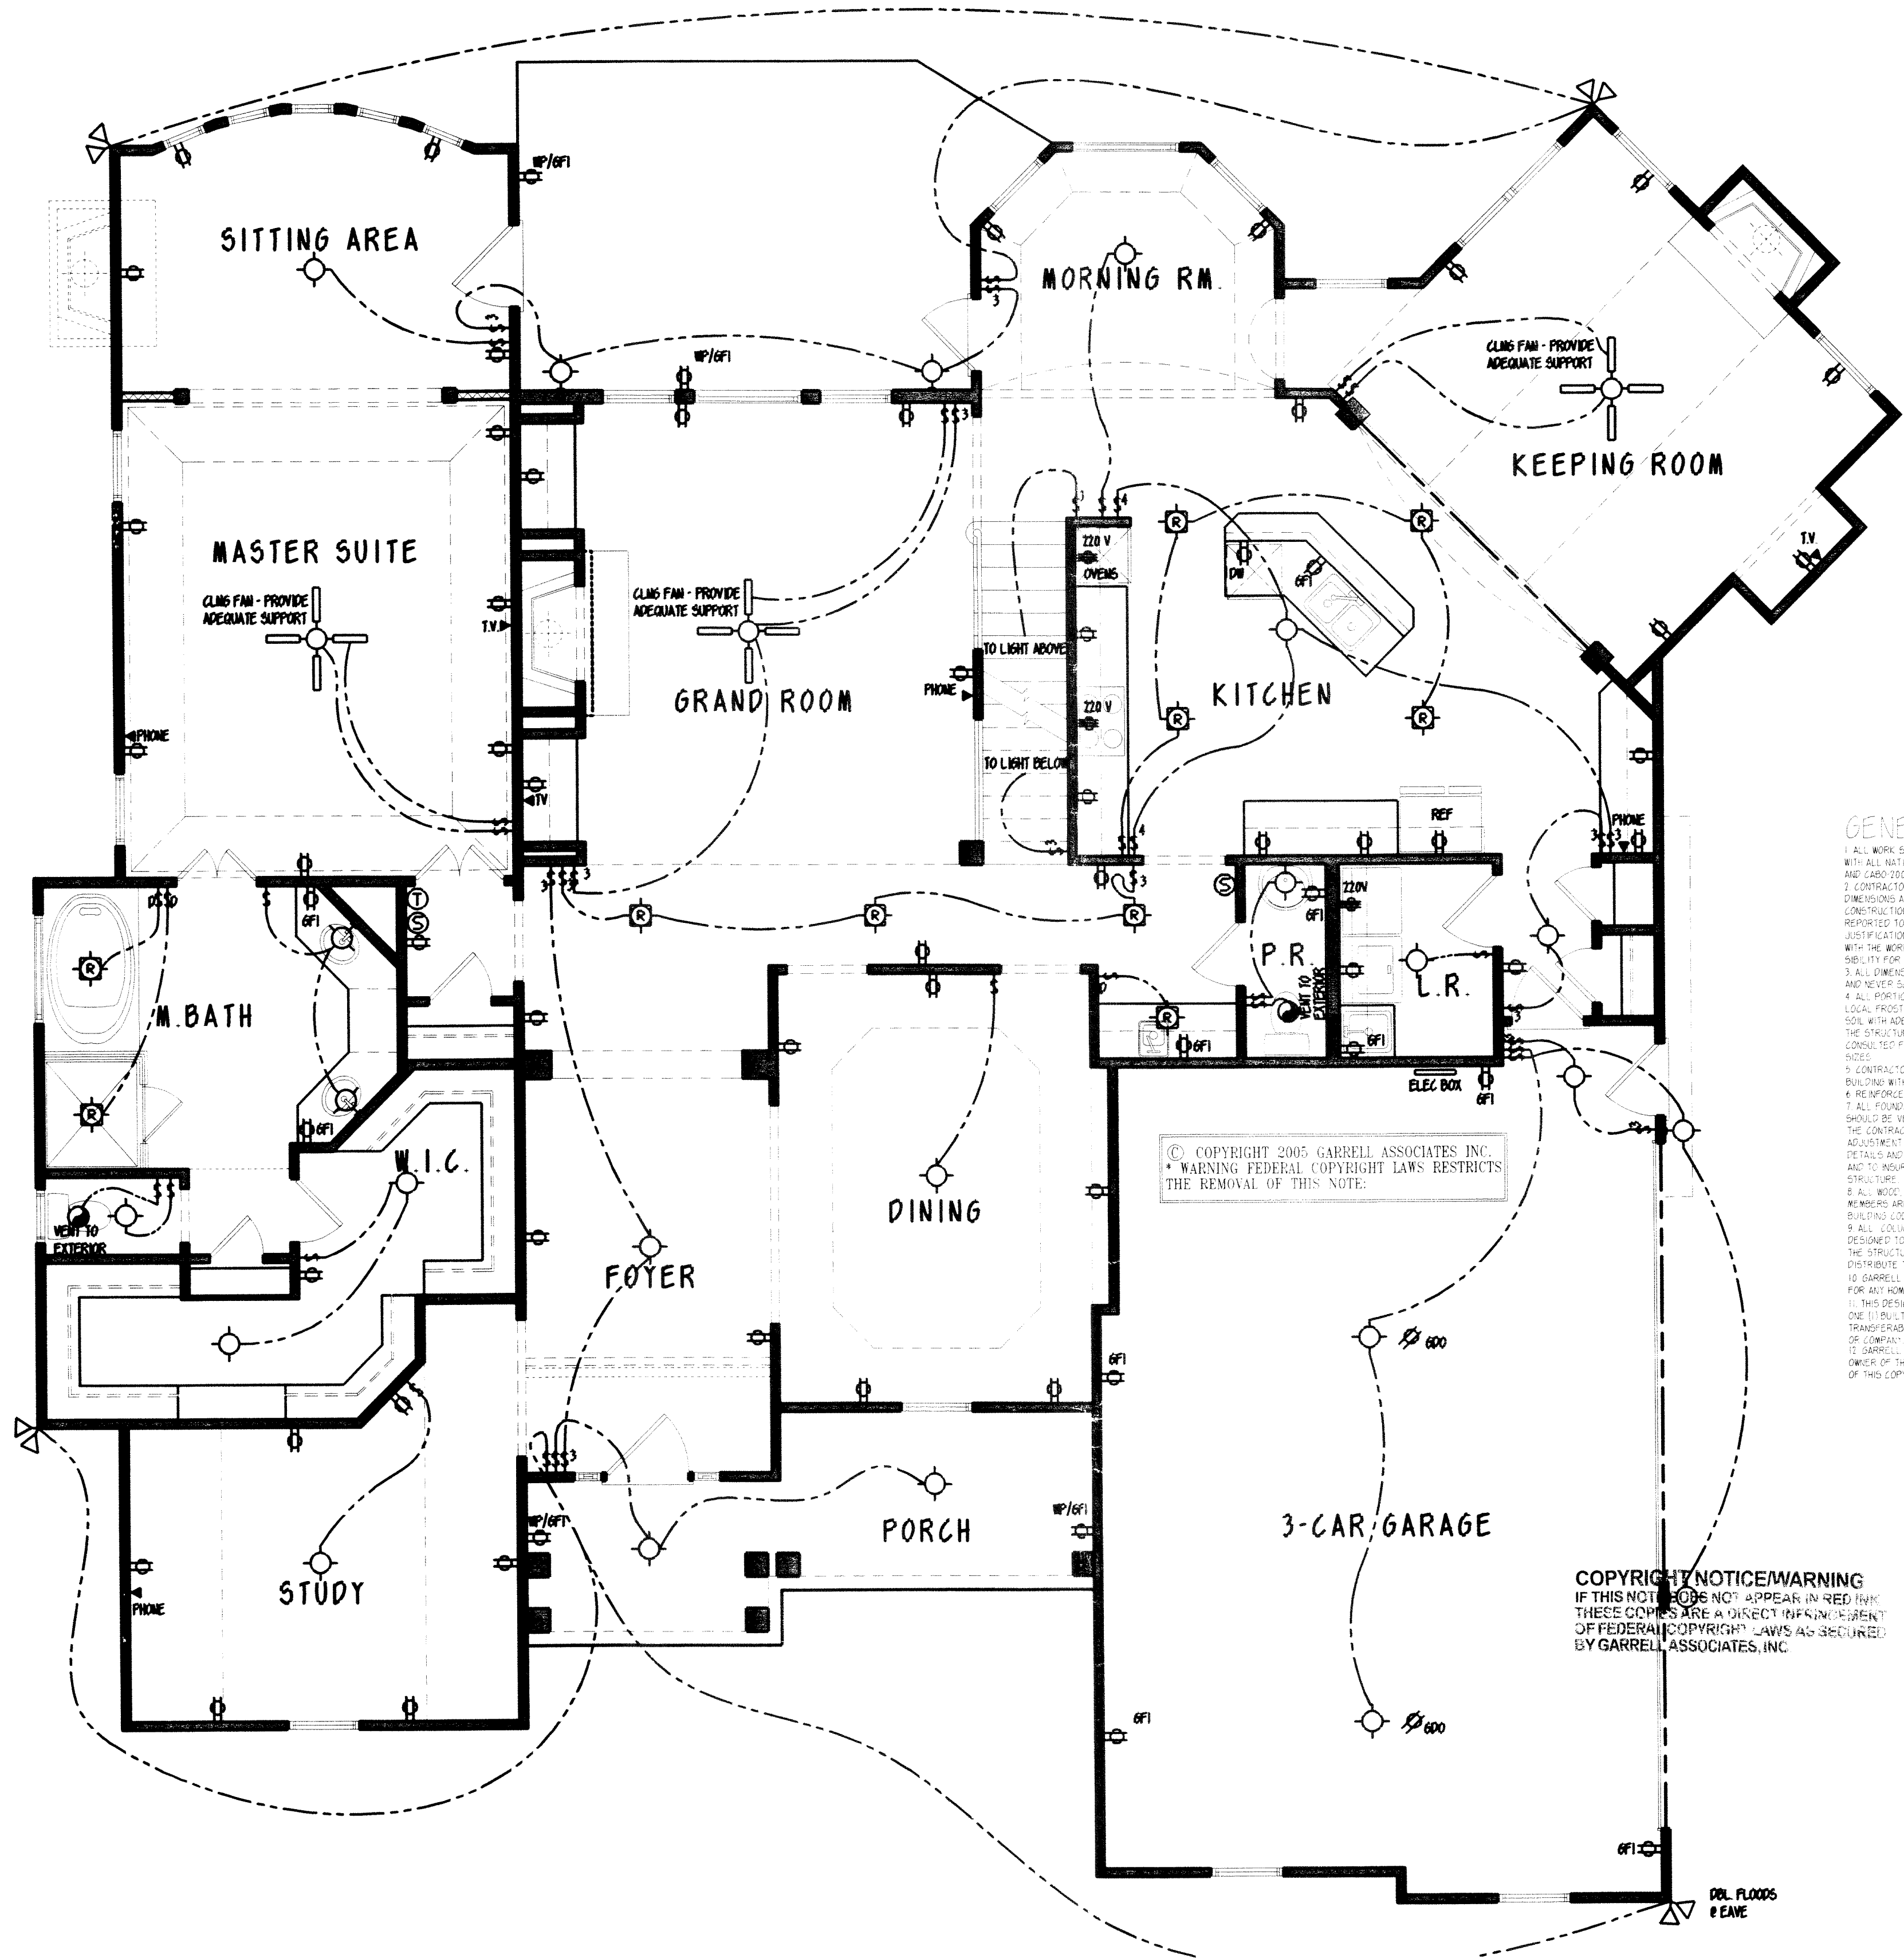

GENERAL NOTES

1. ALL WORK SHALL BE PERFORMED IN ACCORDANCE WITH ALL NATIONAL AND LOCAL CODES, REGULATIONS AND 2005 INTERNATIONAL BUILDING CODES.
2. CONTRACTOR SHALL VERIFY ALL CONDITIONS AND DIMENSIONS AT THE SITE BEFORE BEGINNING CONSTRUCTION. ANY DISCREPANCIES SHALL BE REPORTED TO GARRELL ASSOCIATES, INC. FOR JUSTIFICATION OF CORRECTION BEFORE PROCEEDING WITH THE WORK. CONTRACTOR SHALL ASSUME RESPONSIBILITY FOR ERRORS THAT ARE NOT REPORTED.
3. ALL DIMENSIONS SHALL BE READ OFF, CALCULATED AND NEVER SCALE.
4. ALL PORTIONS OF FOOTINGS ARE TO BE SET ON LOCAL FRONT LINES AND MUST REST ON UNDISTURBED SOIL WITH ADEQUATE BEARING CAPACITY TO SUPPORT THE STRUCTURE. A LOCAL ENGINEER MUST BE CONSULTED FOR PROPER FOOTING AND REINFORCEMENT SIZES.
5. CONTRACTOR TO ENSURE COMPATIBILITY OF THE BUILDING WITH ALL SITE REQUIREMENTS.
6. REINFORCE FOUNDATION WALLS FOR LOCAL CODES.
7. ALL FOUNDATION AND STRUCTURAL MEMBERS SHOULD BE REVIEWED AND STAMPED BY AN ENGINEER. THE CONTRACTOR IS RESPONSIBLE FOR THE ADJUSTMENT AND VERIFICATION OF ALL STRUCTURAL DETAILS AND CONDITIONS TO MEET ALL LOCAL CODES AND TO INSURE A WELL CONSTRUCTED AND SAFE STRUCTURE.
8. ALL ROOF, CONCRETE AND STEEL STRUCTURAL MEMBERS ARE TO MEET NATIONAL, STATE AND LOCAL BUILDING CODES.
9. ALL COLUMNS OR SOLID FRAMING SHALL BE DESIGNED TO CARRY AND TRANSMIT LOADS THROUGH THE STRUCTURE TO FOUNDATION ELEMENTS THAT DISTRIBUTE THE LOADS TO FULL CAPACITY SOILS.
10. GARRELL ASSOCIATES ASSUMES NO LIABILITY FOR ANY HOME CONSTRUCTED FROM THIS PLAN.
11. THIS DESIGN/DESIGN IS RELEASED FOR ONE (1) BUILT STRUCTURE ONLY AND IS NOT TRANSFERABLE TO ANOTHER INDIVIDUAL OR COMPANY.
12. GARRELL ASSOCIATES, INC. IS THE SOLE OWNER OF THIS OR ANY CREATIVE NOTIFICATION OF THIS COPYRIGHT PROTECTED PLAN.

COPYRIGHT NOTICE/WARNING
 IF THIS NOTE DOES NOT APPEAR IN RED INK, THESE COPIES ARE A DIRECT INFRINGEMENT OF FEDERAL COPYRIGHT LAWS AS SECURED BY GARRELL ASSOCIATES, INC.

FIRST FLOOR ELECTRICAL PLAN

SCALE: 1/4" = 1'-0"

NOTE: THE DESIGN DIRECTED IN THESE DRAWINGS ARE PROTECTED UNDER FEDERAL COPYRIGHT LAWS AND ARE NOT RELEASED TO THIRD PARTIES FOR REPRODUCTION OF ANY DERIVATIVE WORKS OR ANY OTHER WORKS. THESE DRAWINGS AND ITS REPRODUCTIONS ARE THE PROPERTY OF GARRELL ASSOCIATES, INC. AND MAY NOT BE USED OR REPRODUCED WITHOUT THE EXPRESSED WRITTEN CONSENT OF GARRELL ASSOCIATES, INC.

PLAN BOOK

GARRELL ASSOCIATES, INC.
 790 PEACHTREE IND. BLVD.
 SUITE 200, SUWANEE, GA 30024
 PHONE (770) 611-2334
 WWW.GARRELLASSOCIATES.COM

TRE'S MAISON FIRST FLOOR ELECTRICAL PLAN

2-23-01

REV. NO.	REV. DATE
1	4-7-05 TC

THIS COPYRIGHTED DESIGN IS THE SOLE PROPERTY OF GARRELL ASSOCIATES, INC. AND MAY NOT BE USED OR REPRODUCED WITHOUT THE EXPRESSED WRITTEN CONSENT OF GARRELL ASSOCIATES, INC.

CAUTION: ONLY A QUALIFIED DESIGNER, ARCHITECT, CONTRACTOR, OR STRUCTURAL ENGINEER SHOULD ATTEMPT TO MODIFY THIS PLAN.

01049	
DRAWN	SHEET NO.
VD	W1